



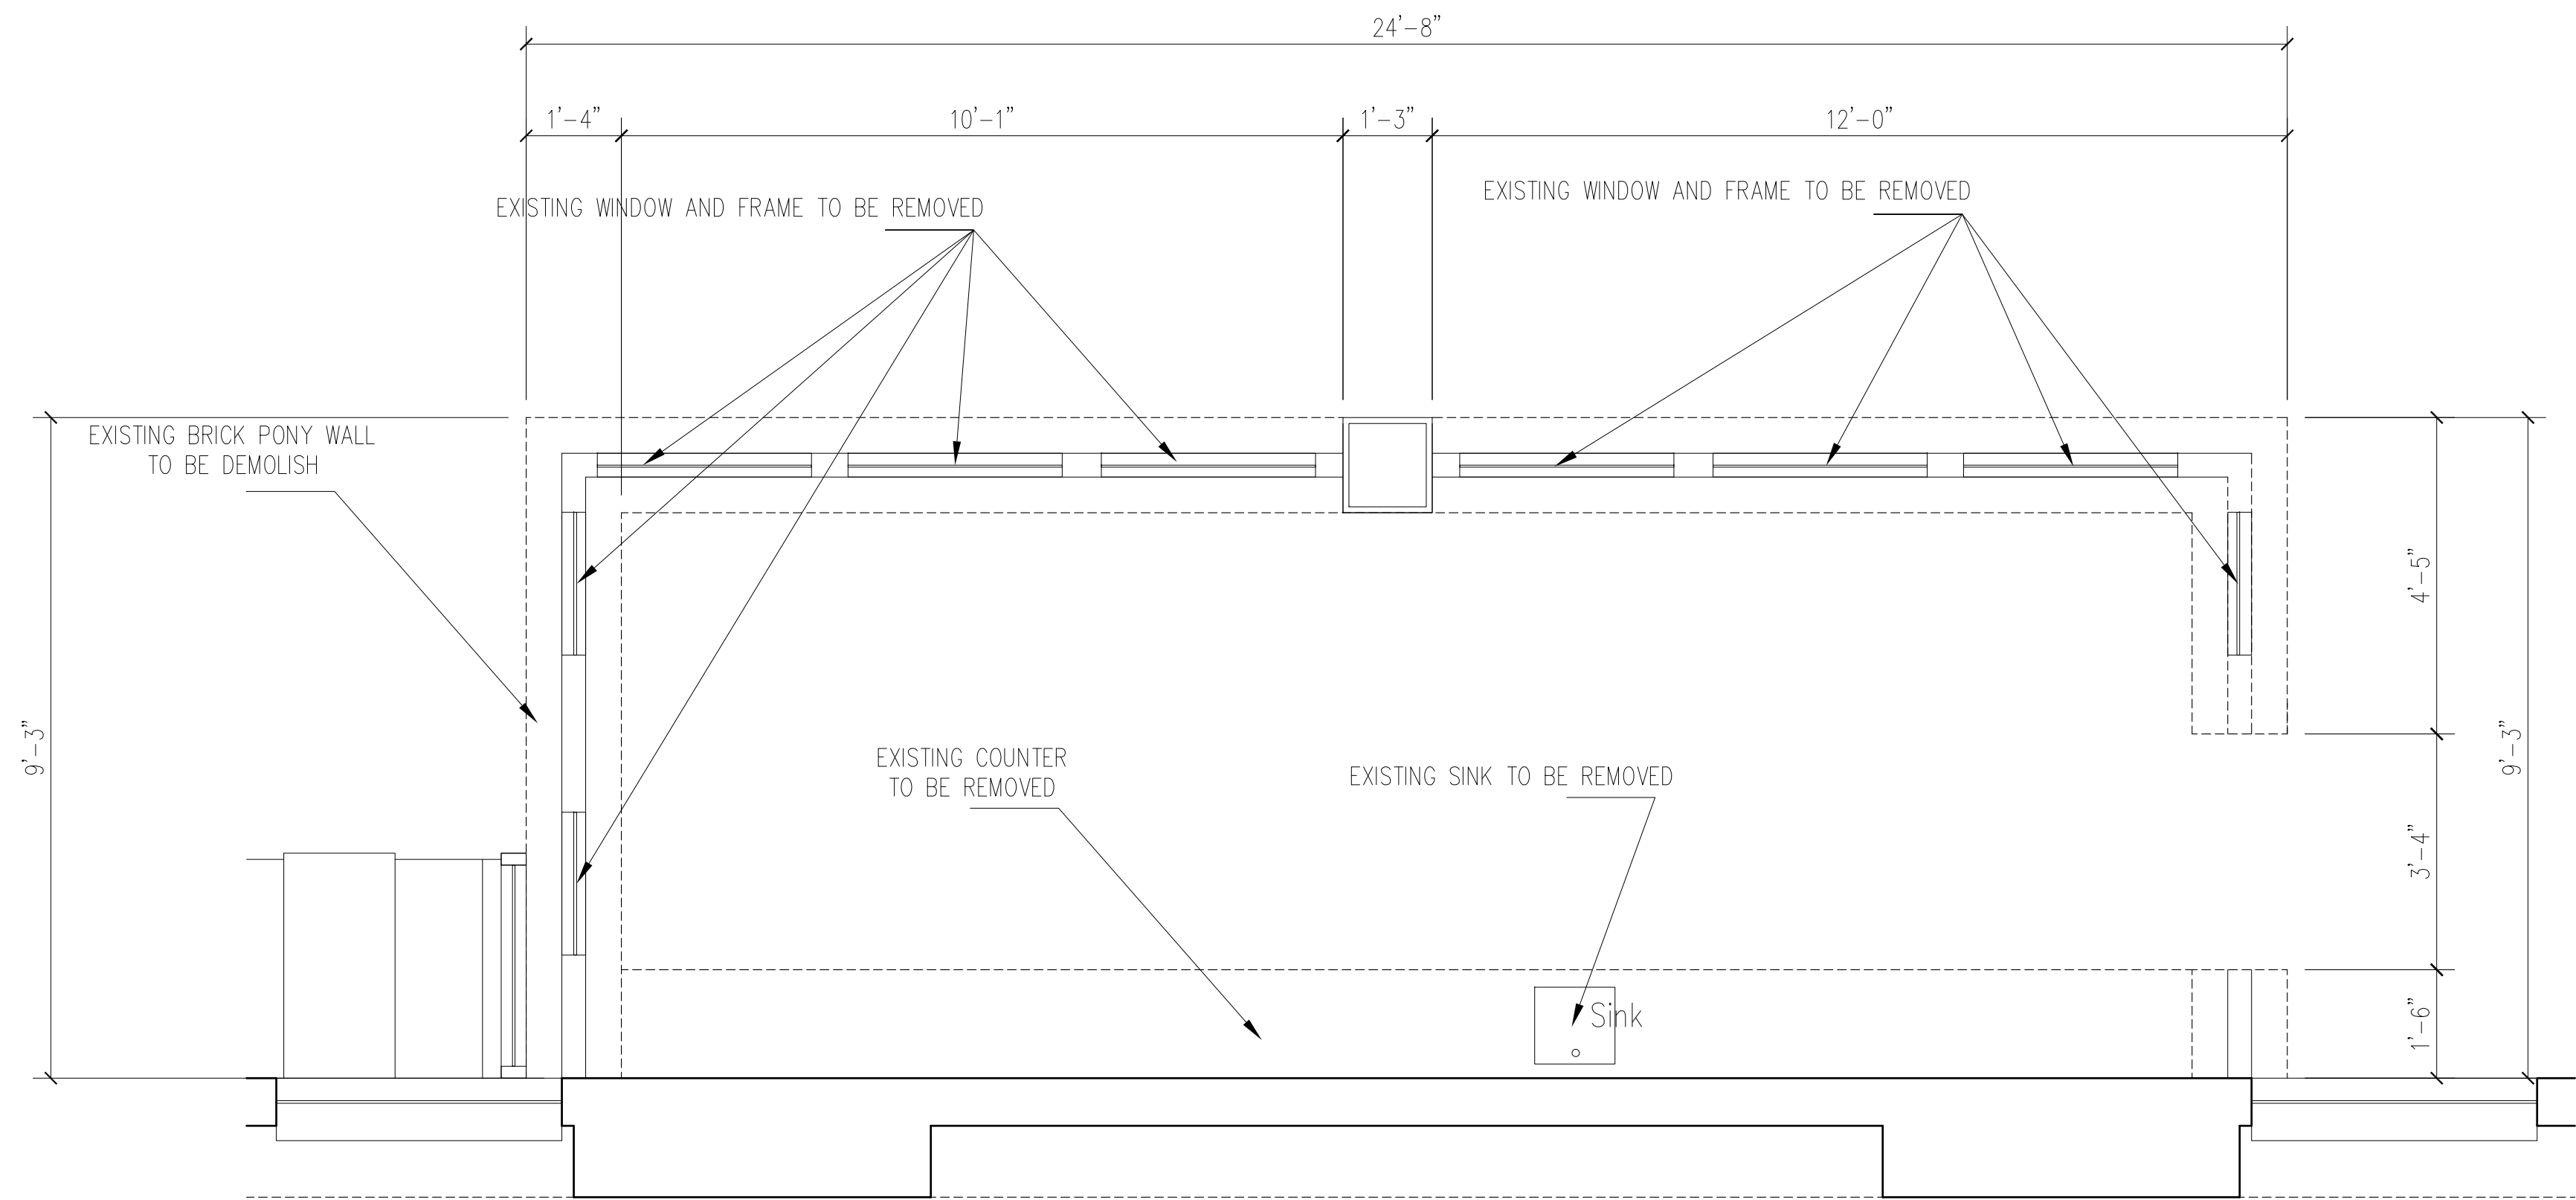

EXISTING FLOOR PLAN

BAR AREA


SCALE : 1/2" = 1'-0"

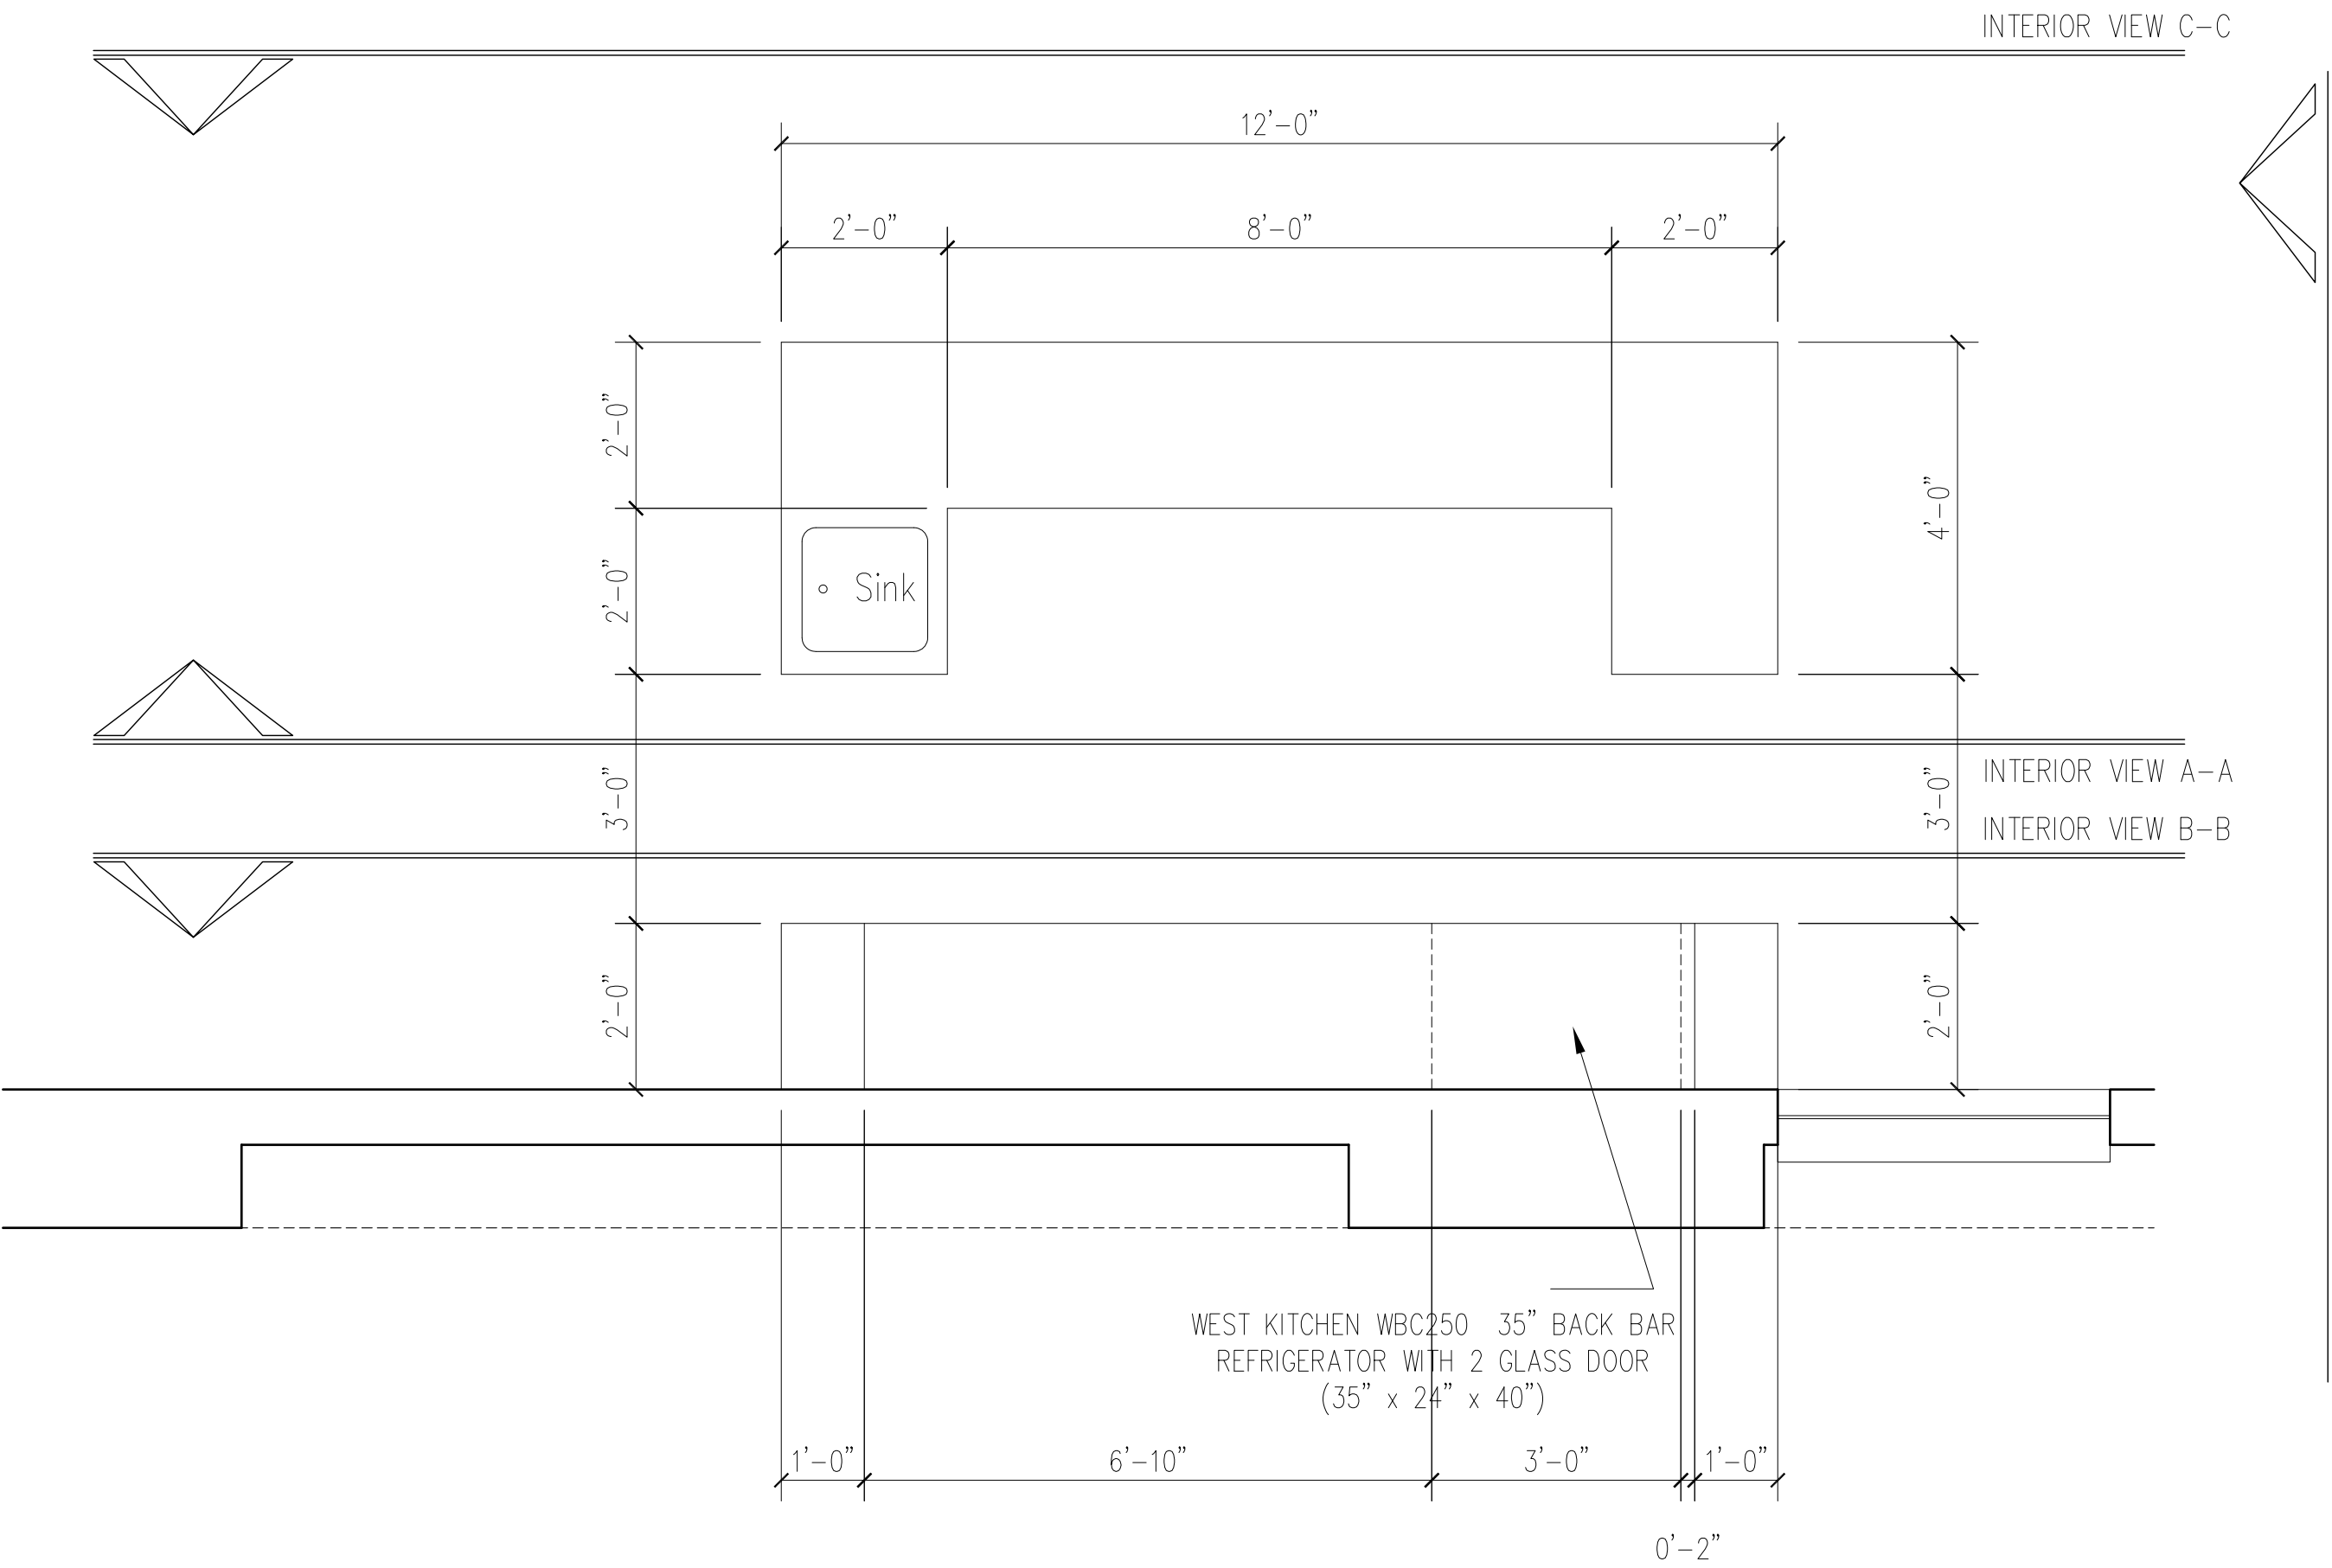

NEW FLOOR PLAN

BAR AREA


SCALE : 1/2" = 1'-0"

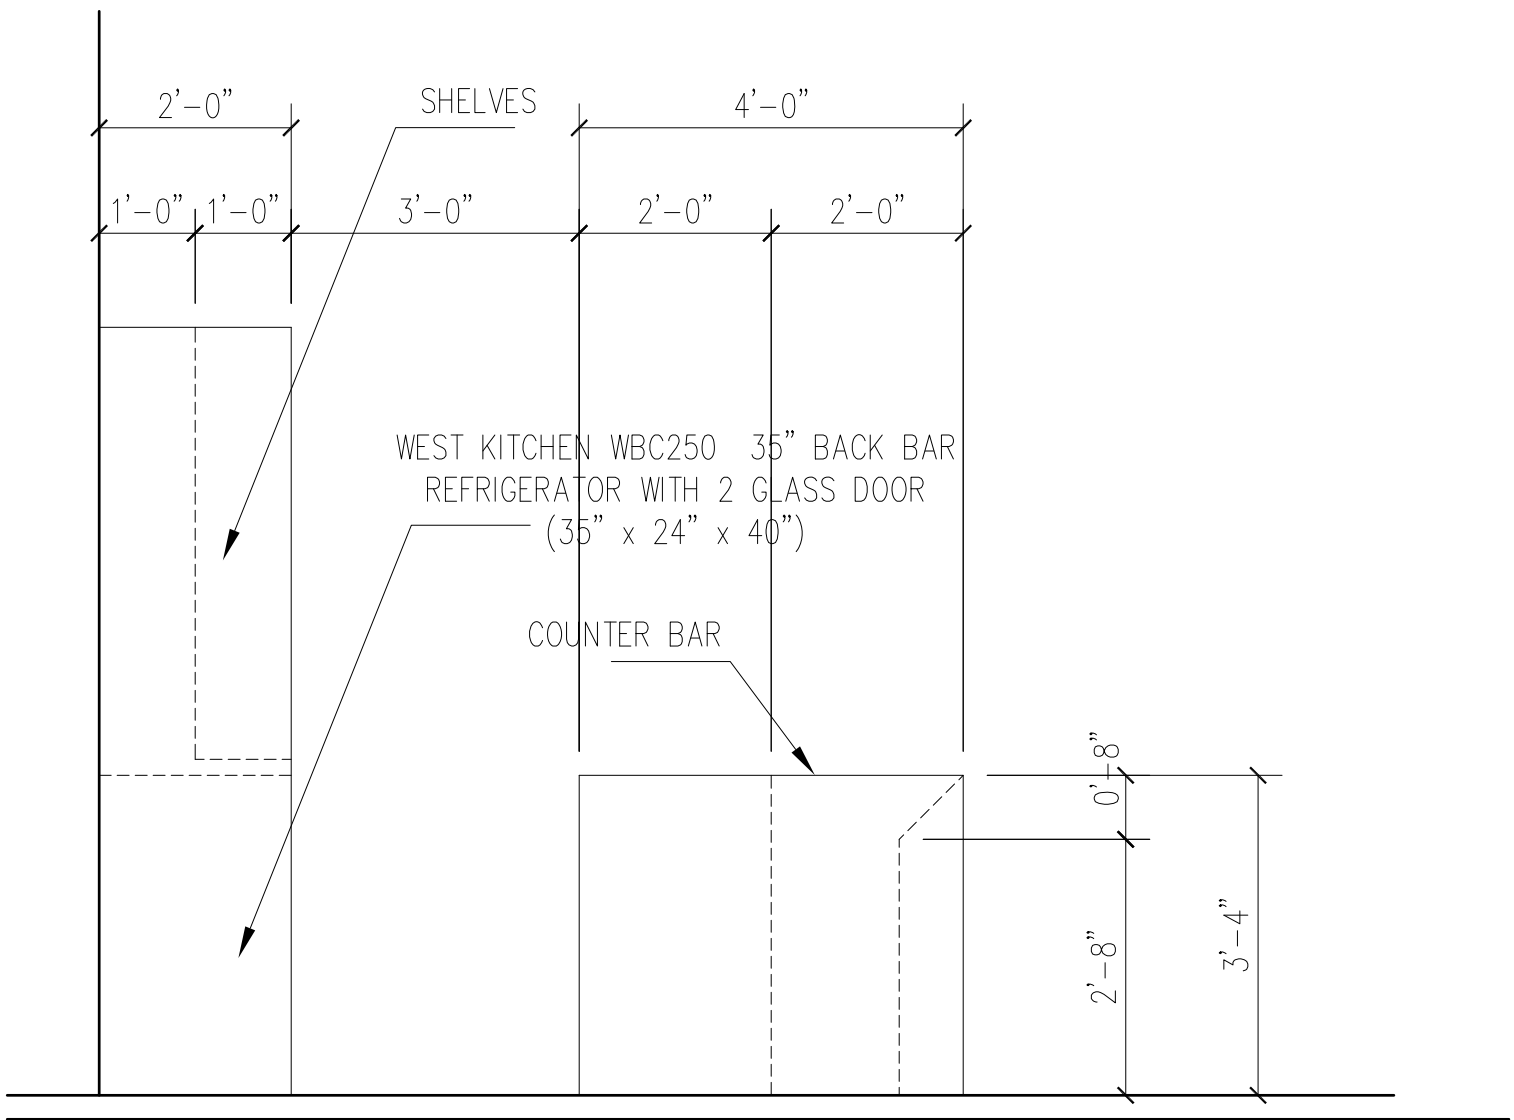

INTERIOR VIEW D-D

BAR AREA


SCALE : 1/2" = 1'-0"

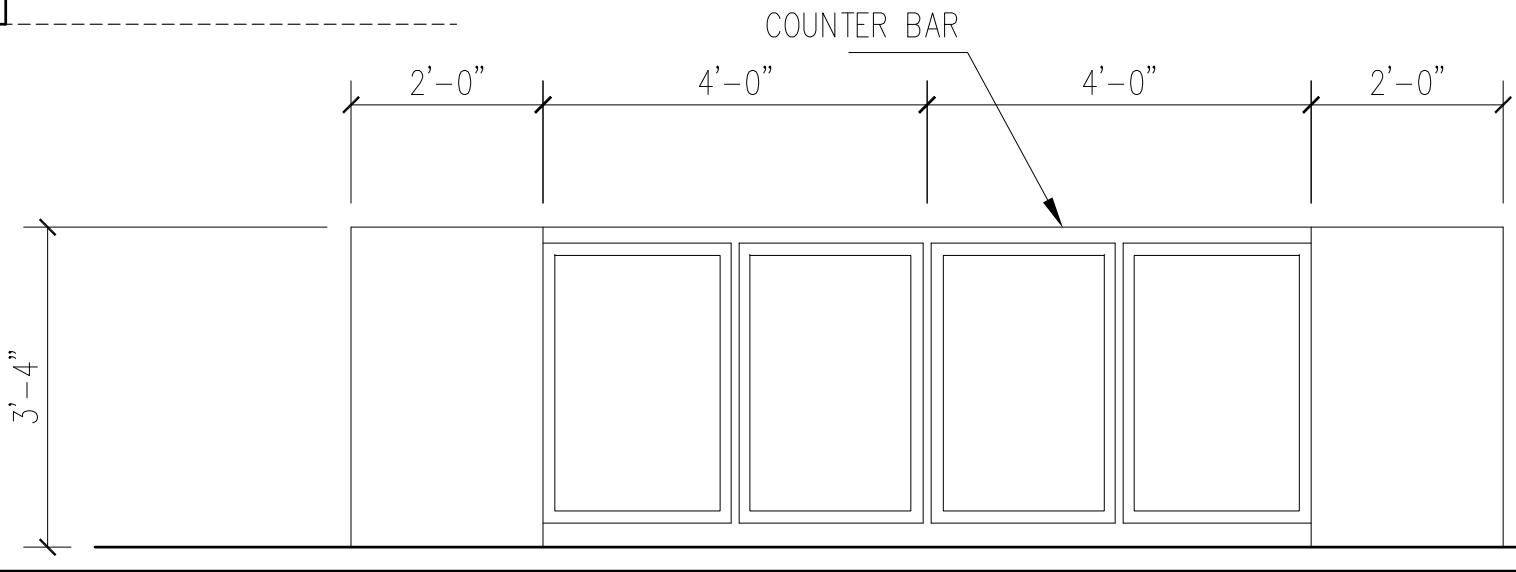

INTERIOR VIEW A-A

BAR AREA


SCALE : 1/2" = 1'-0"

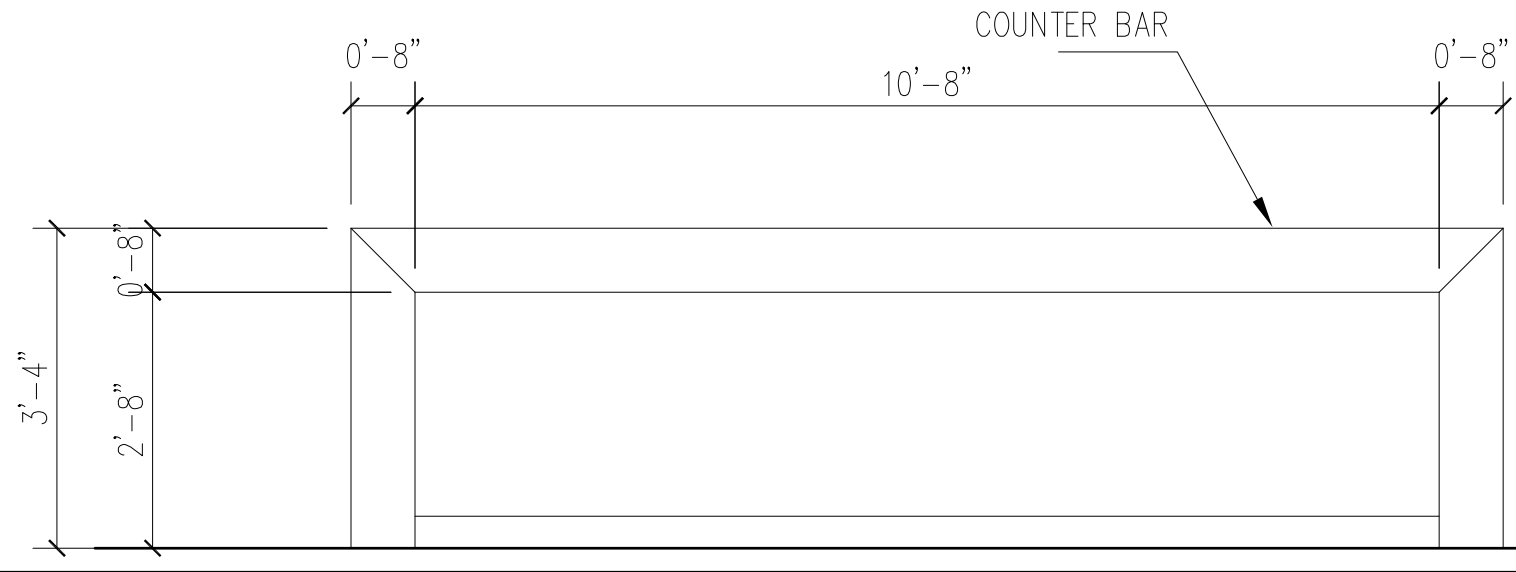

INTERIOR VIEW C-C

BAR AREA


SCALE : 1/2" = 1'-0"

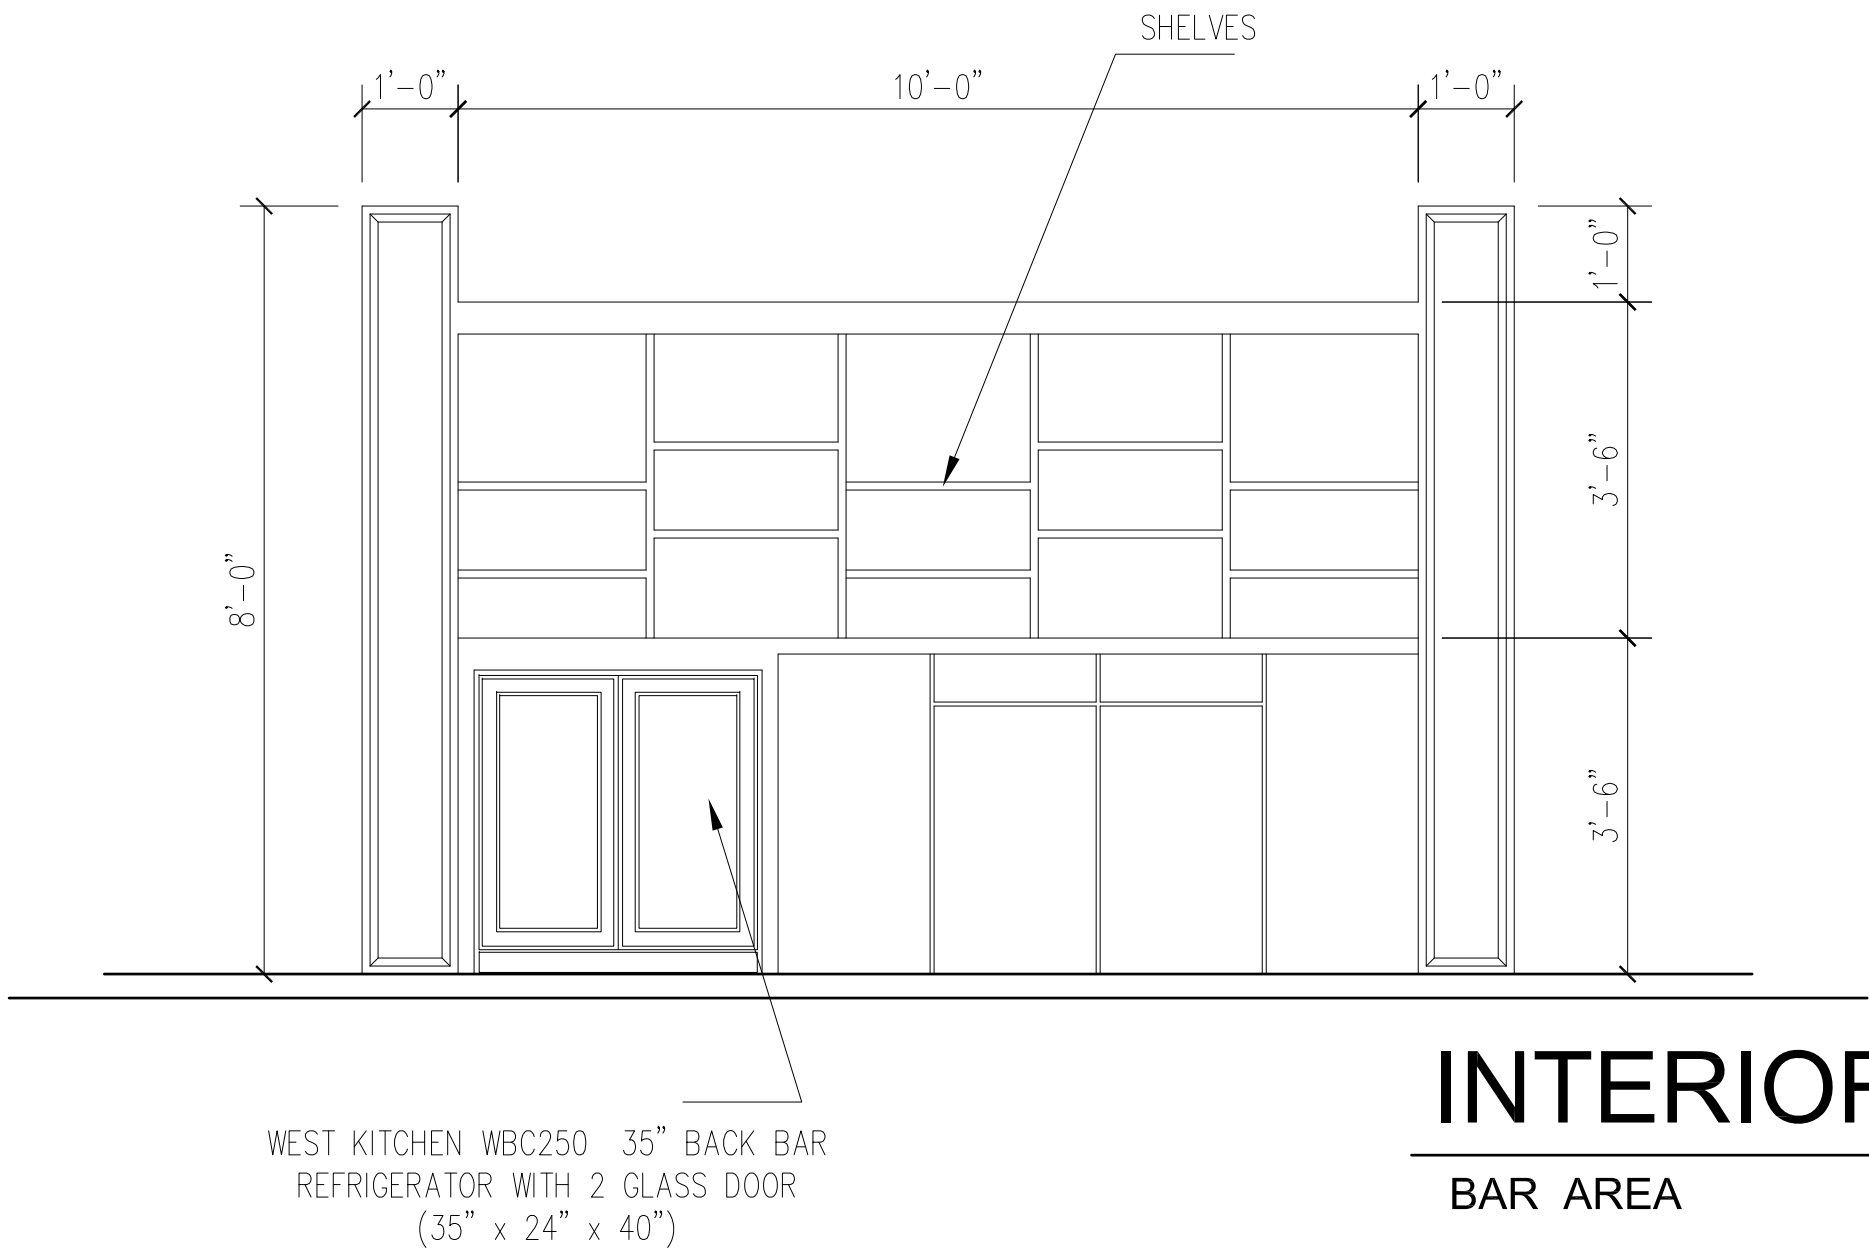

INTERIOR VIEW B-B

BAR AREA

SCALE : 1/2" = 1'-0"

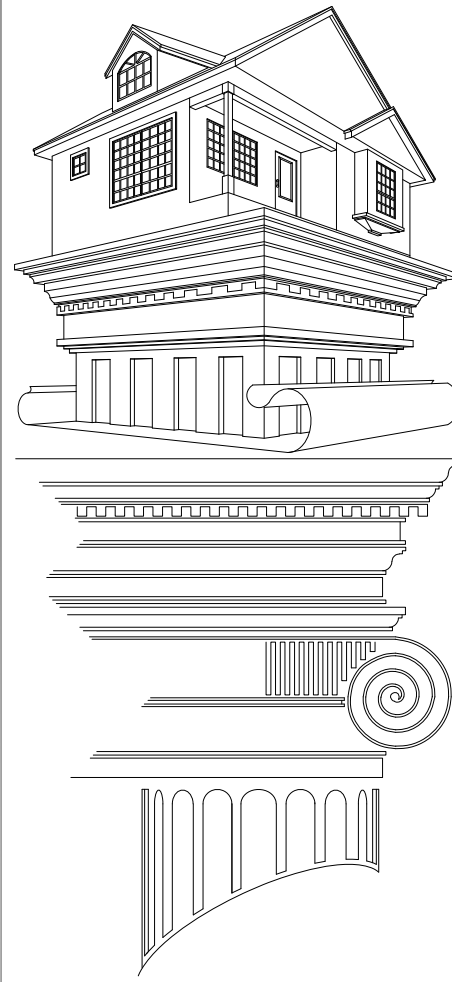

Martinez Design, LLC


Tel. : 972-891-4160
Tel. : 972-871-2512

martinezbd73@hotmail.com

GENERAL NOTES

1. THE GENERAL CONTRACTOR/BUILDER SHALL EXAMINE AND VERIFY THE ACCURACY OF ALL DIMENSIONS AND CONDITIONS OF THESE PLANS/DOCUMENTS. THE CONTRACTOR SHALL ALSO NOTIFY THE OWNER IF THERE ARE ANY DISCREPANCIES AND/OR OMISSIONS PRIOR TO THE BEGINNING OF THE CONSTRUCTION.
2. THESE PLANS ARE INTENDED FOR THE GENERAL COMMERCIAL CONSTRUCTION PURPOSES ONLY AND ARE NOT EXHAUSTIVELY DETAILED OR FULLY SPECIFIED.
3. THE GENERAL CONTRACTOR SHALL SUPERVISE THE CONSTRUCTION AND SHALL BE HIS/HER RESPONSIBILITY TO SELECT, VERIFY, RESOLVE, AND INSTALL ALL EQUIPMENT AND MATERIALS AS WELL AS TO CONTROL THE QUALITY OF THE PROJECT.
4. ALL WORK PERFORMED ON THIS PROJECT SHALL MEET OR EXCEED THE CURRENT EDITION OF THE UNIFORM BUILDING CODE AND ALL APPLICABLE STATE AND LOCAL ORDINANCES, CODE, AND REGULATIONS.
5. IT IS THE RESPONSIBILITY OF THE GENERAL CONTRACTOR TO PROVIDE ANY ENGINEERING NECESSARY TO THE STABILITY OF THE STRUCTURE(S) OF THE PROJECT. FURTHERMORE IT RECOMMENDS THAT THESE PLANS SHALL BE REVIEWED BY A QUALIFIED PROFESSIONAL ENGINEER AND TOPOGRAPHIC SPECIALIST

SQUARE FOOTAGE

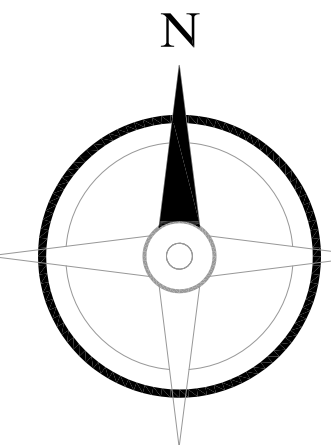

Project Name:

EXISTING RESTAURANT
INTERIOR REMODEL

Project Address:

900 W AIRPORT FWY
HURST, TX 76054

Plan Name:

BAR AREA

Project #:

100724

Drawn By:

JAM

Date:

10-07-2024

Scale:


3/16" = 1'-0"

Sheet #:

Of:


7

7

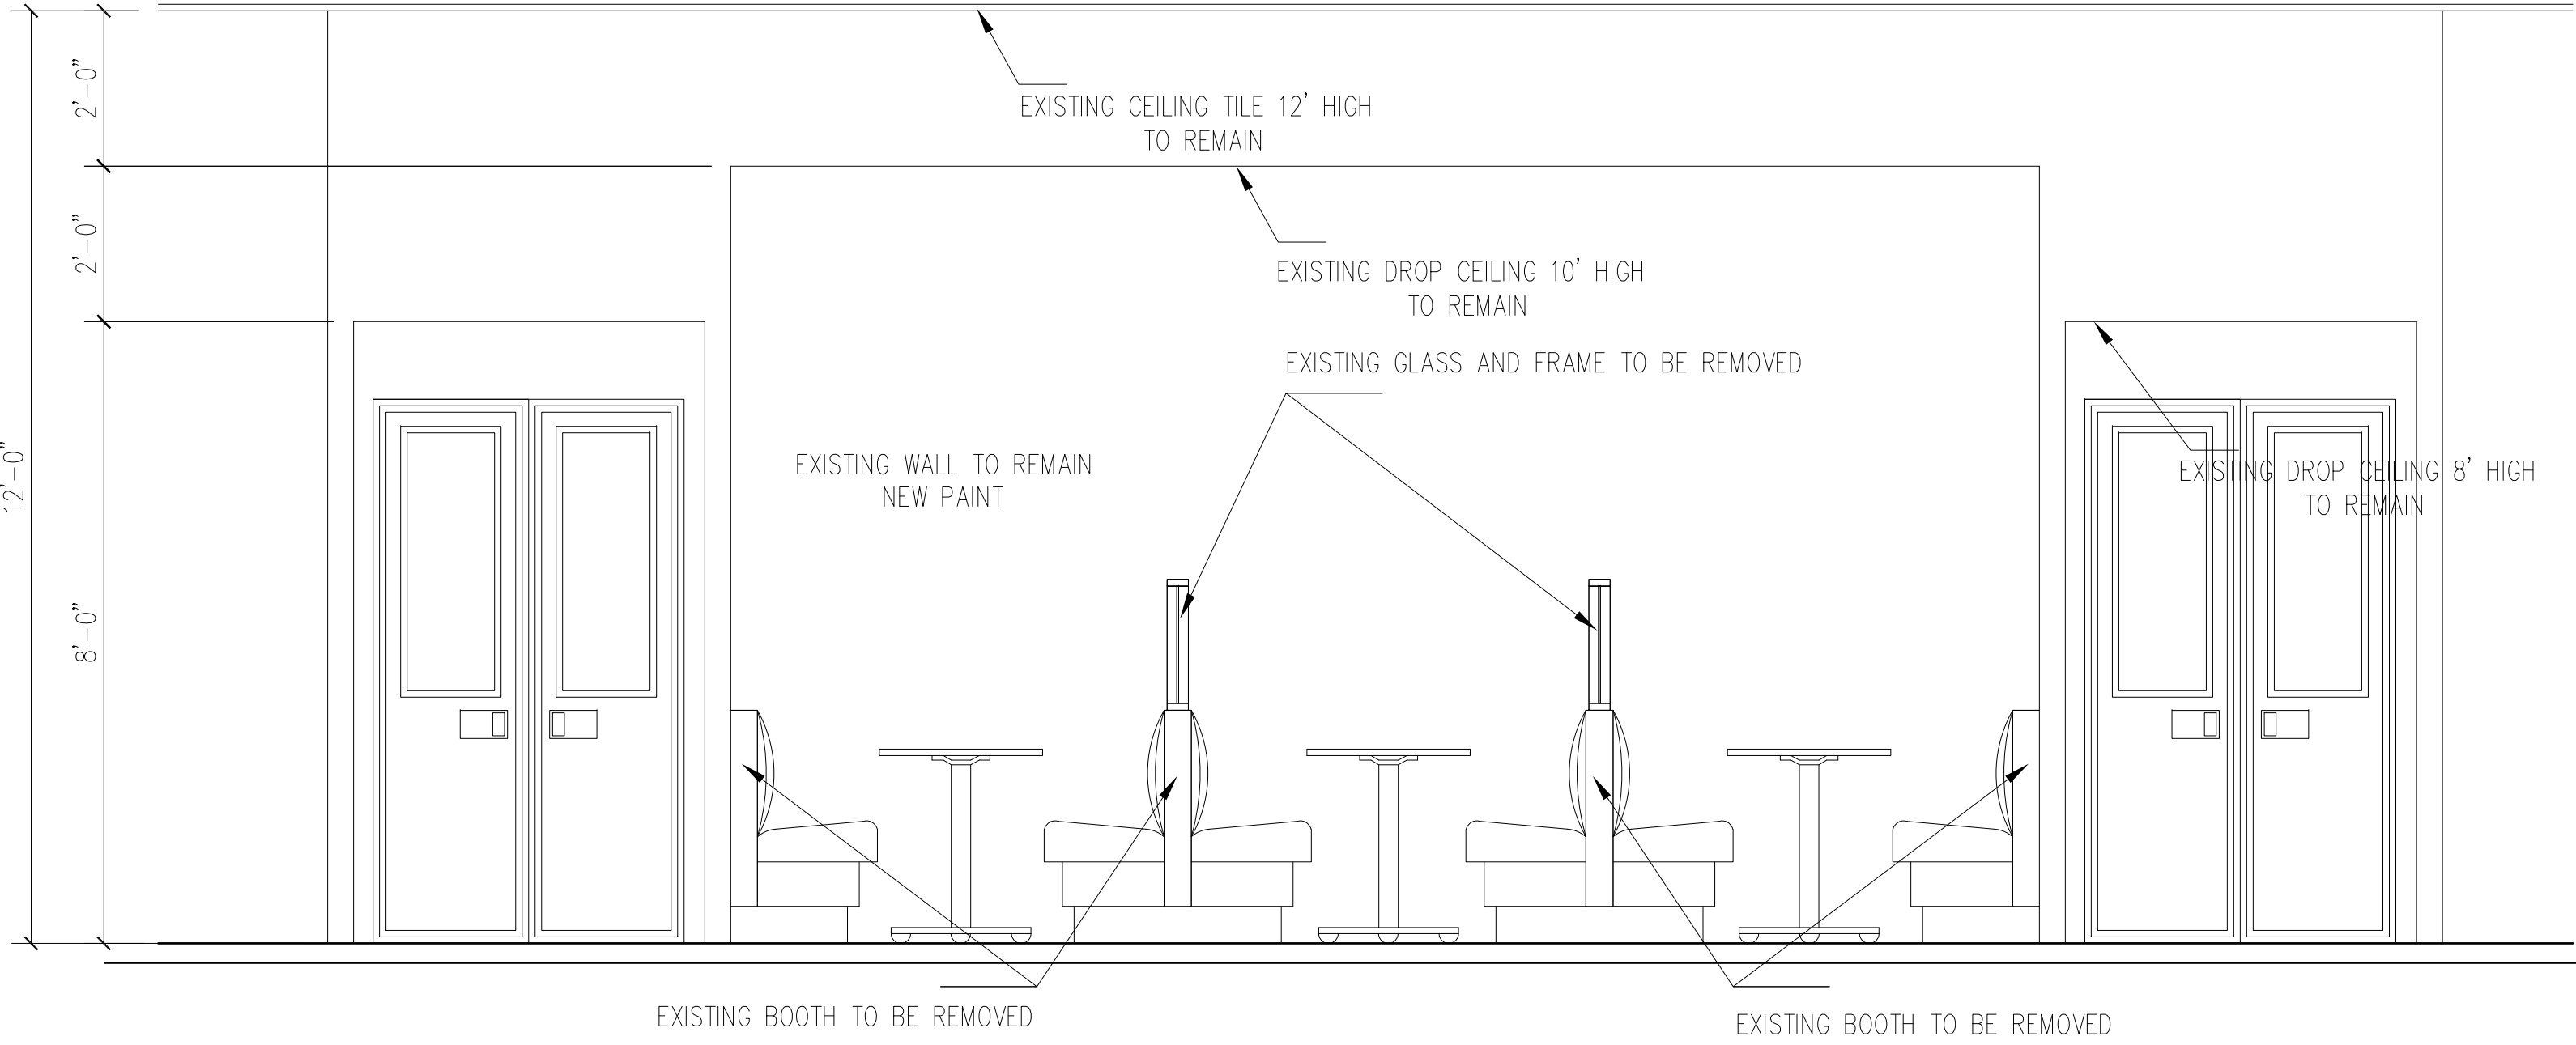


EXISTING INTERIOR VIEW 1-1

BUFFET AREA SCALE : 1/2" = 1'-0"

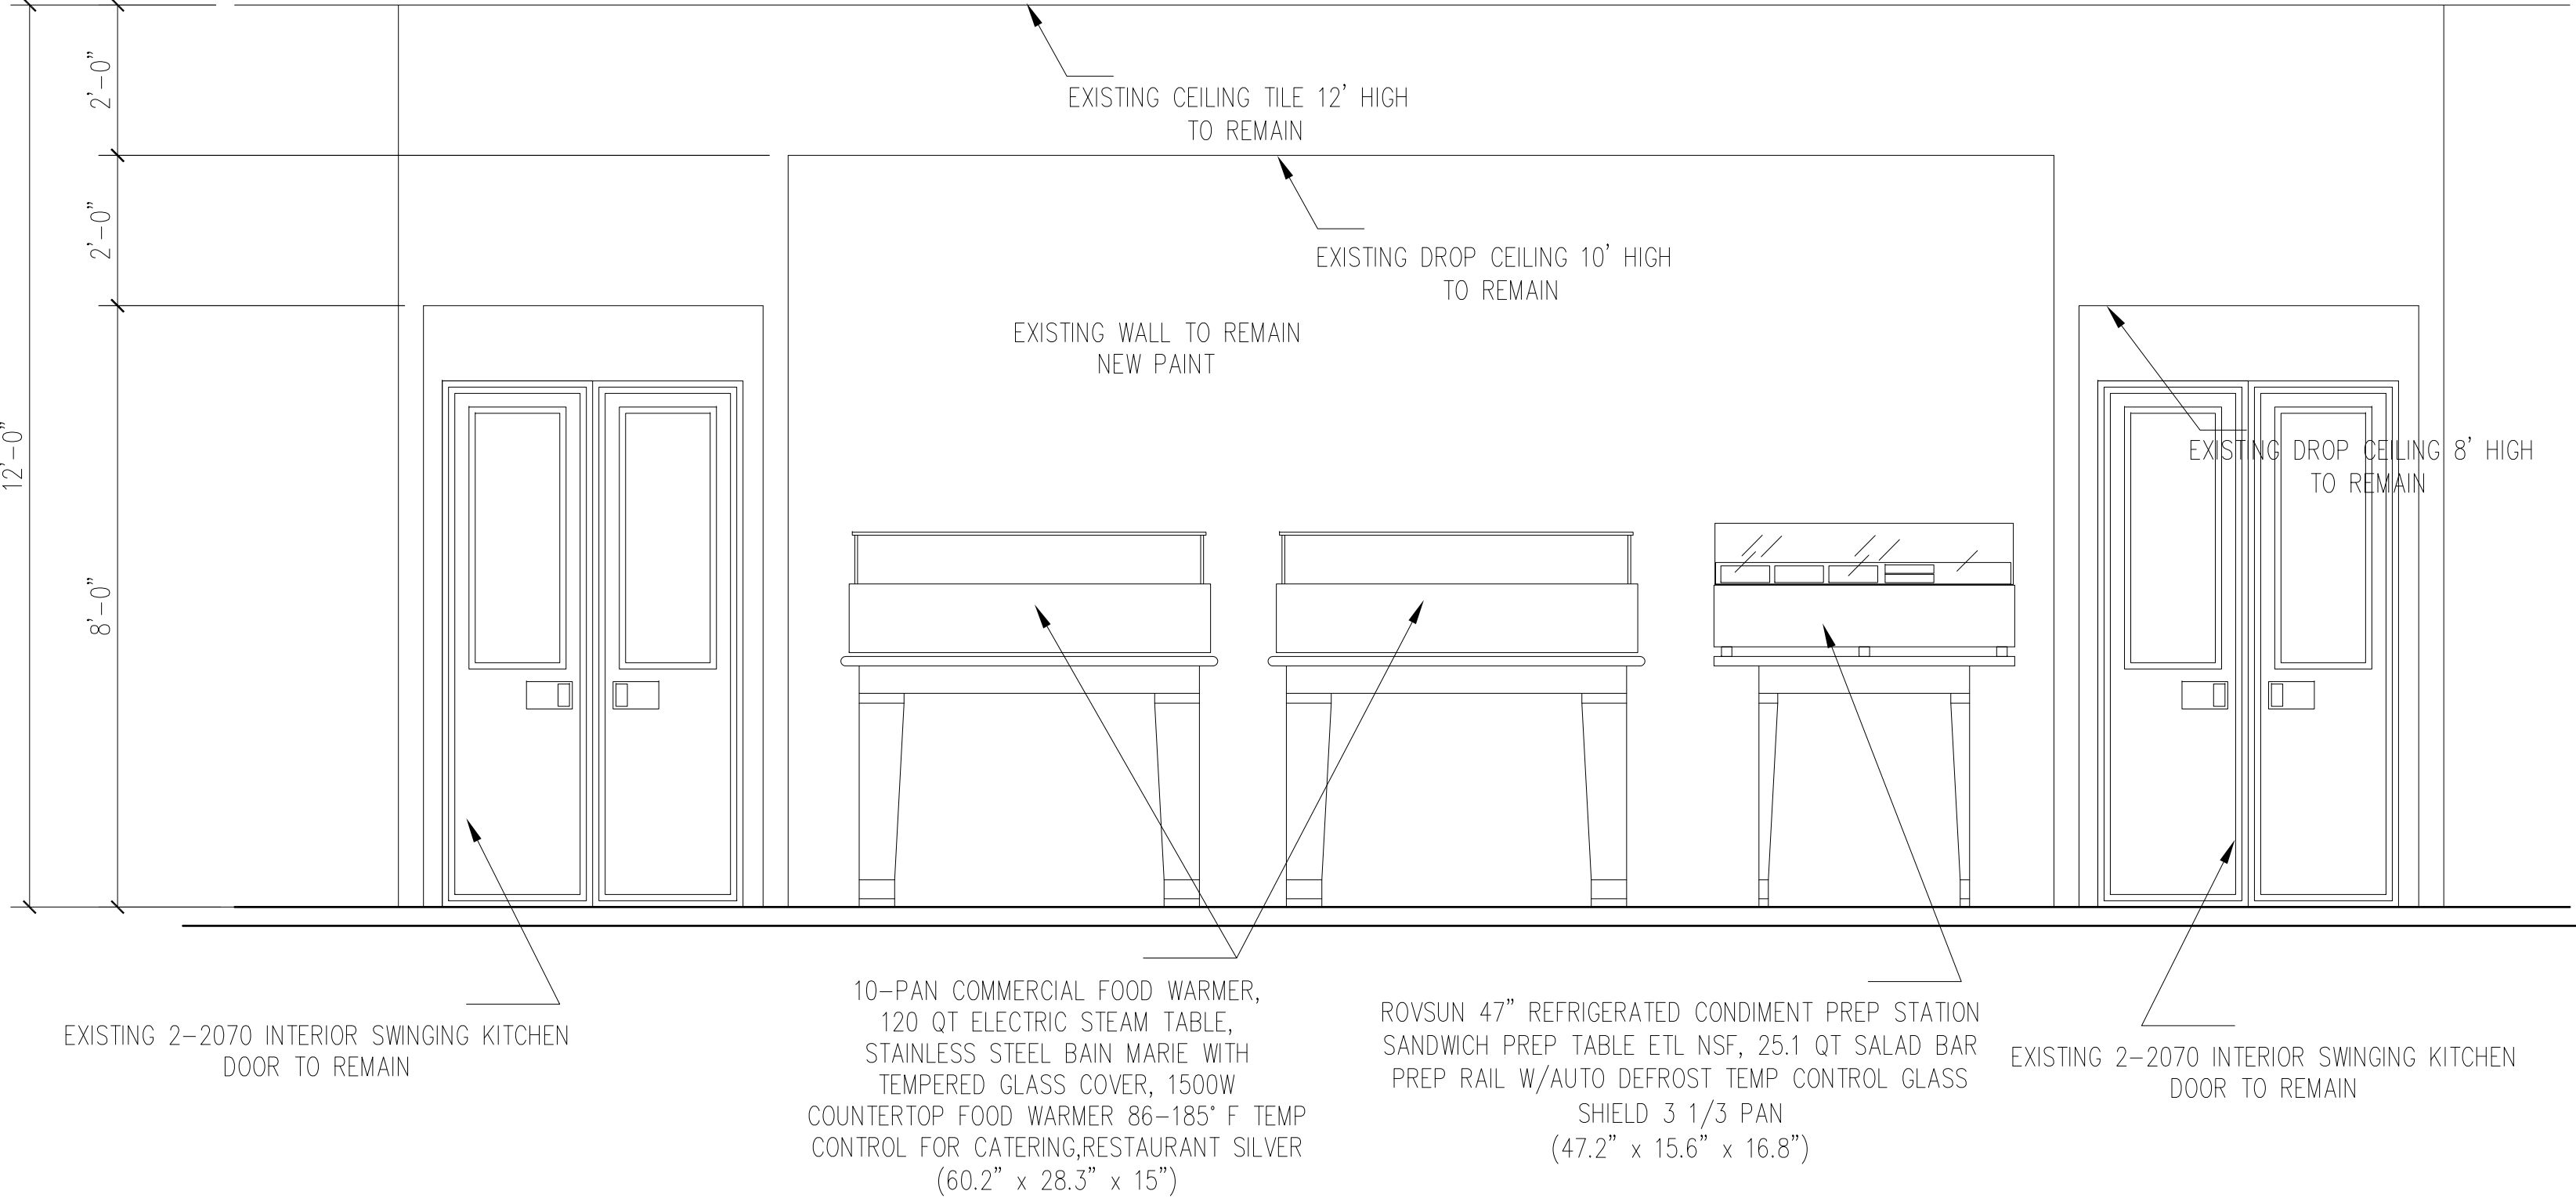


NEW INTERIOR VIEW 1-1

BUFFET AREA SCALE : 1/2" = 1'-0"

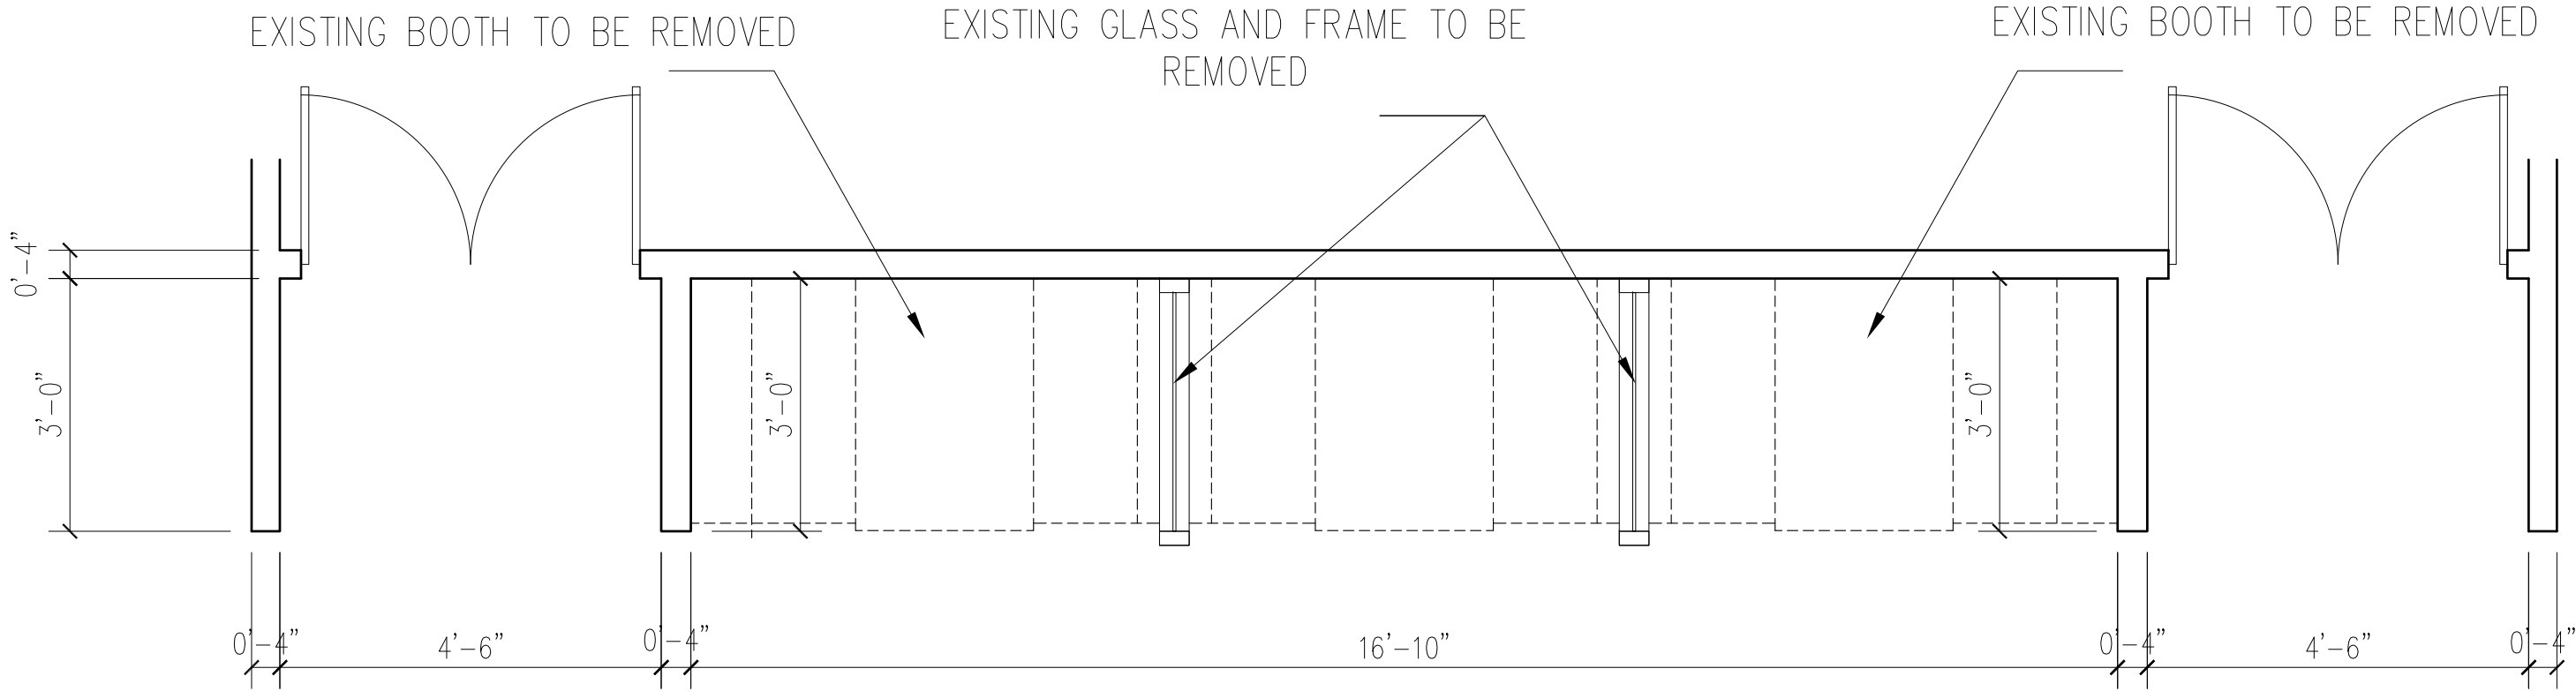


EXISTING FLOOR PLAN

BUFFET AREA SCALE : 1/2" = 1'-0"

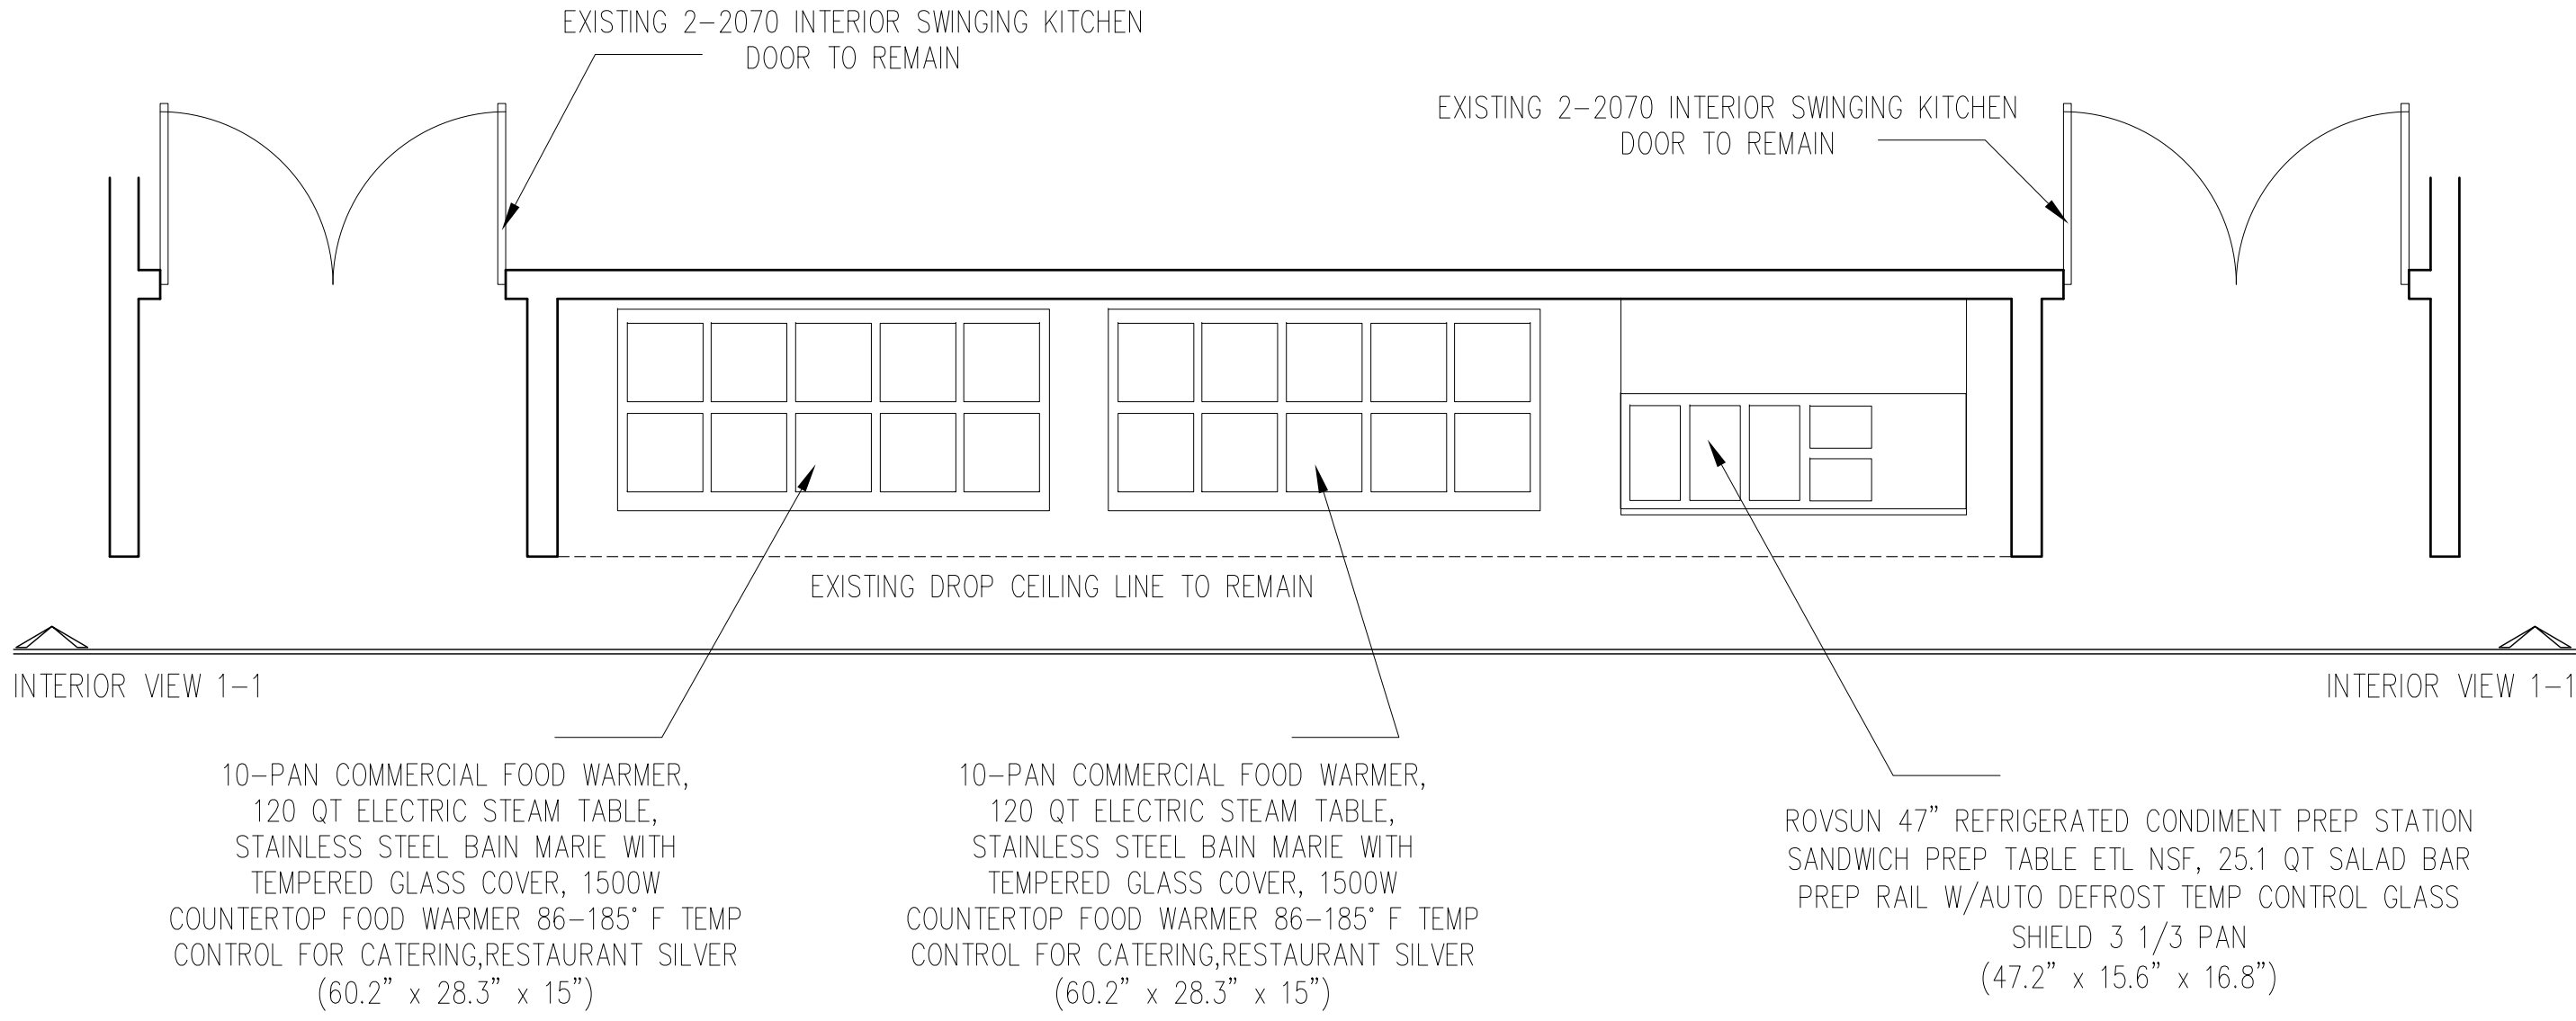


NEW FLOOR PLAN

BUFFET AREA SCALE : 1/2" = 1'-0"

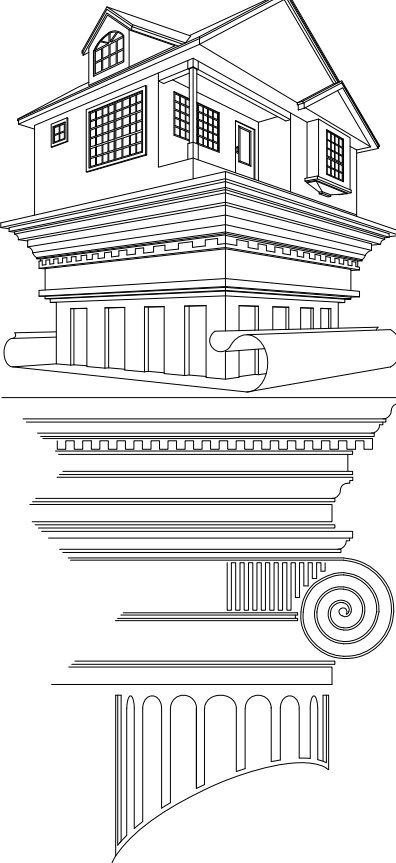

Martinez Design, LLC
Tel : 972-891-4180
Tel : 972-871-2512
martinezab7@hotmail.com

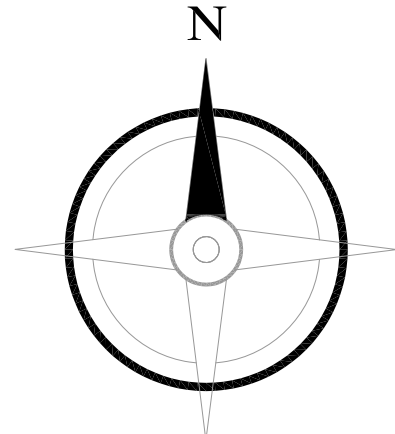

Project Name:

**EXISTING RESTAURANT
INTERIOR REMODEL**

Project Address:

**900 W AIRPORT FWY
HURST, TX 76054**


Plan Name:

NEW BUFFET AREA

Project #:	100724	Drawn By:	JAM
Date:	10-07-2024	Scale:	3/16" = 1'-0"
Sheet #:	6	Of:	7


GENERAL NOTES

1. THE GENERAL CONTRACTOR/BUILDER SHALL EXAMINE AND VERIFY THE ACCURACY OF ALL DIMENSIONS AND CONDITIONS OF THESE PLANS/DOCUMENTS. THE CONTRACTOR SHALL ALSO NOTIFY THE OWNER IF THERE ARE ANY DISCREPANCIES AND/OR OMISSIONS PRIOR TO THE BEGINNING OF THE CONSTRUCTION.
2. THESE PLANS ARE INTENDED FOR THE GENERAL COMMERCIAL CONSTRUCTION PURPOSES ONLY AND ARE NOT EXHAUSTIVELY DETAILED OR FULLY SPECIFIED.
3. THE GENERAL CONTRACTOR SHALL SUPERVISE THE CONSTRUCTION AND SHALL BE HIS/HER RESPONSIBILITY TO SELECT, VERIFY, RESOLVE, AND INSTALL ALL EQUIPMENT AND MATERIALS AS WELL AS TO CONTROL THE QUALITY OF THE PROJECT.
4. ALL WORK PERFORMED ON THIS PROJECT SHALL MEET OR EXCEED THE CURRENT EDITION OF THE UNIFORM BUILDING CODE AND ALL APPLICABLE STATE AND LOCAL ORDINANCES, CODE, AND REGULATIONS.
5. IT IS THE RESPONSIBILITY OF THE GENERAL CONTRACTOR TO PROVIDE ANY ENGINEERING NECESSARY TO THE STABILITY OF THE STRUCTURE(S) OF THE PROJECT. FURTHERMORE IT RECOMMENDS THAT THESE PLANS SHALL BE REVIEWED BY A QUALIFIED PROFESSIONAL ENGINEER AND TOPOGRAPHIC SPECIALIST

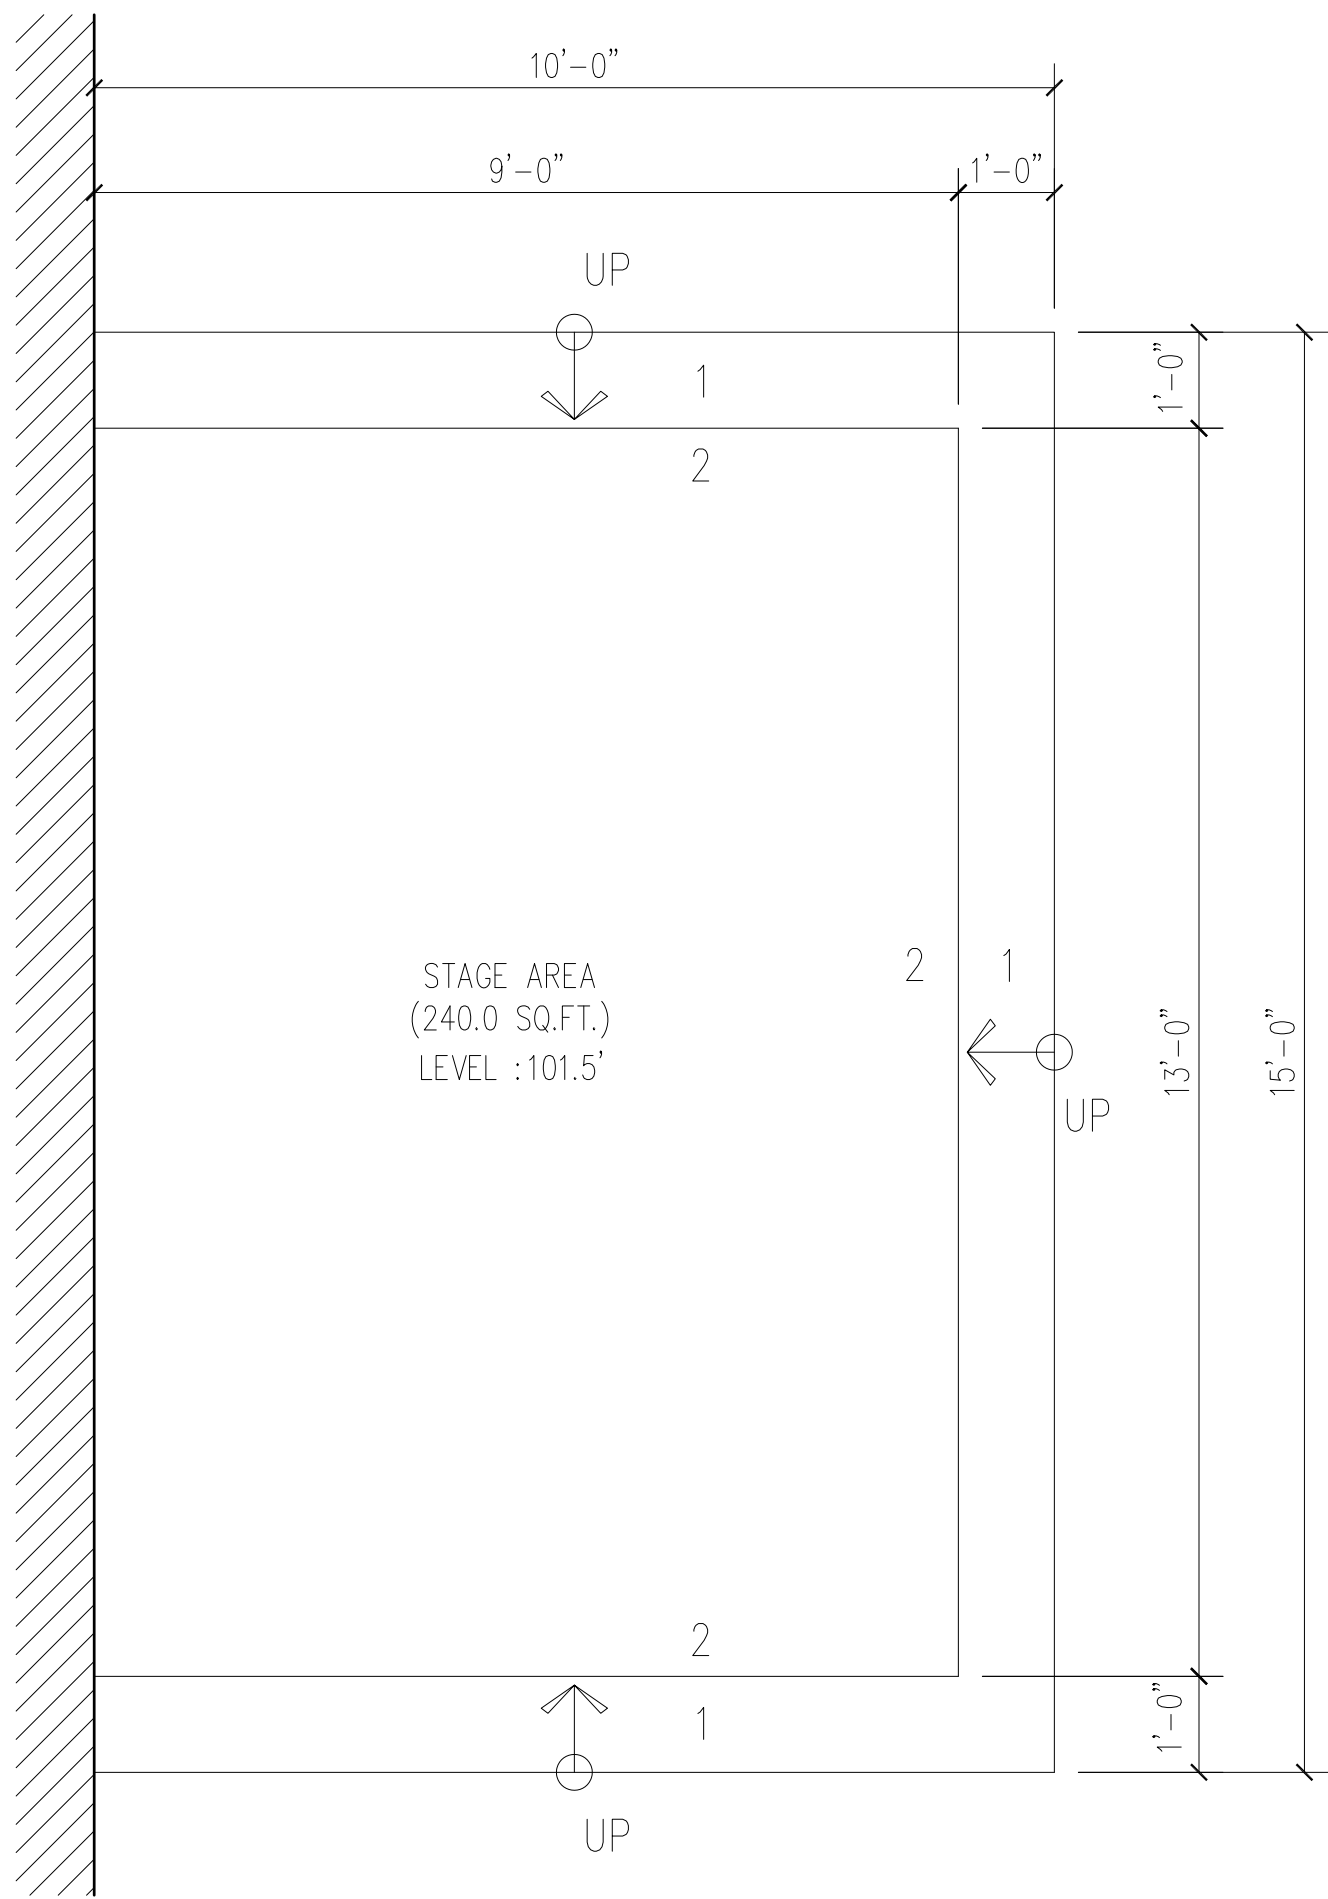


FLOOR PLAN

STAGE SCALE : 1/2" = 1'-0"

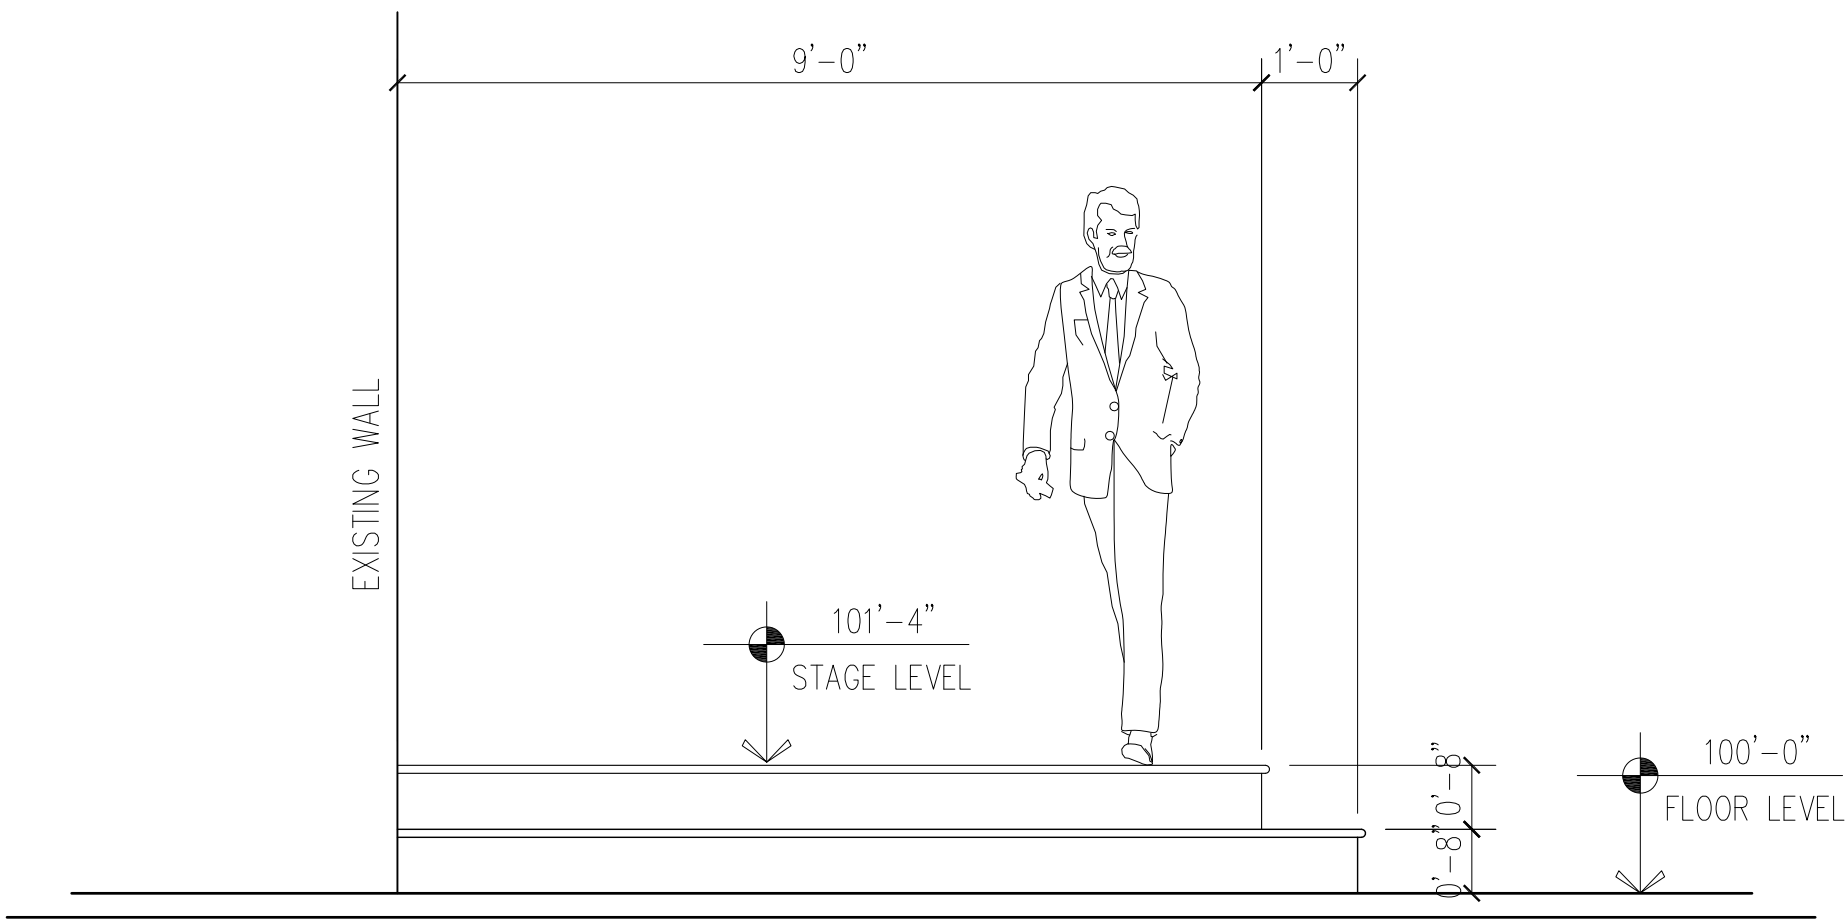


LEFT ELEVATION

STAGE SCALE : 1/2" = 1'-0"

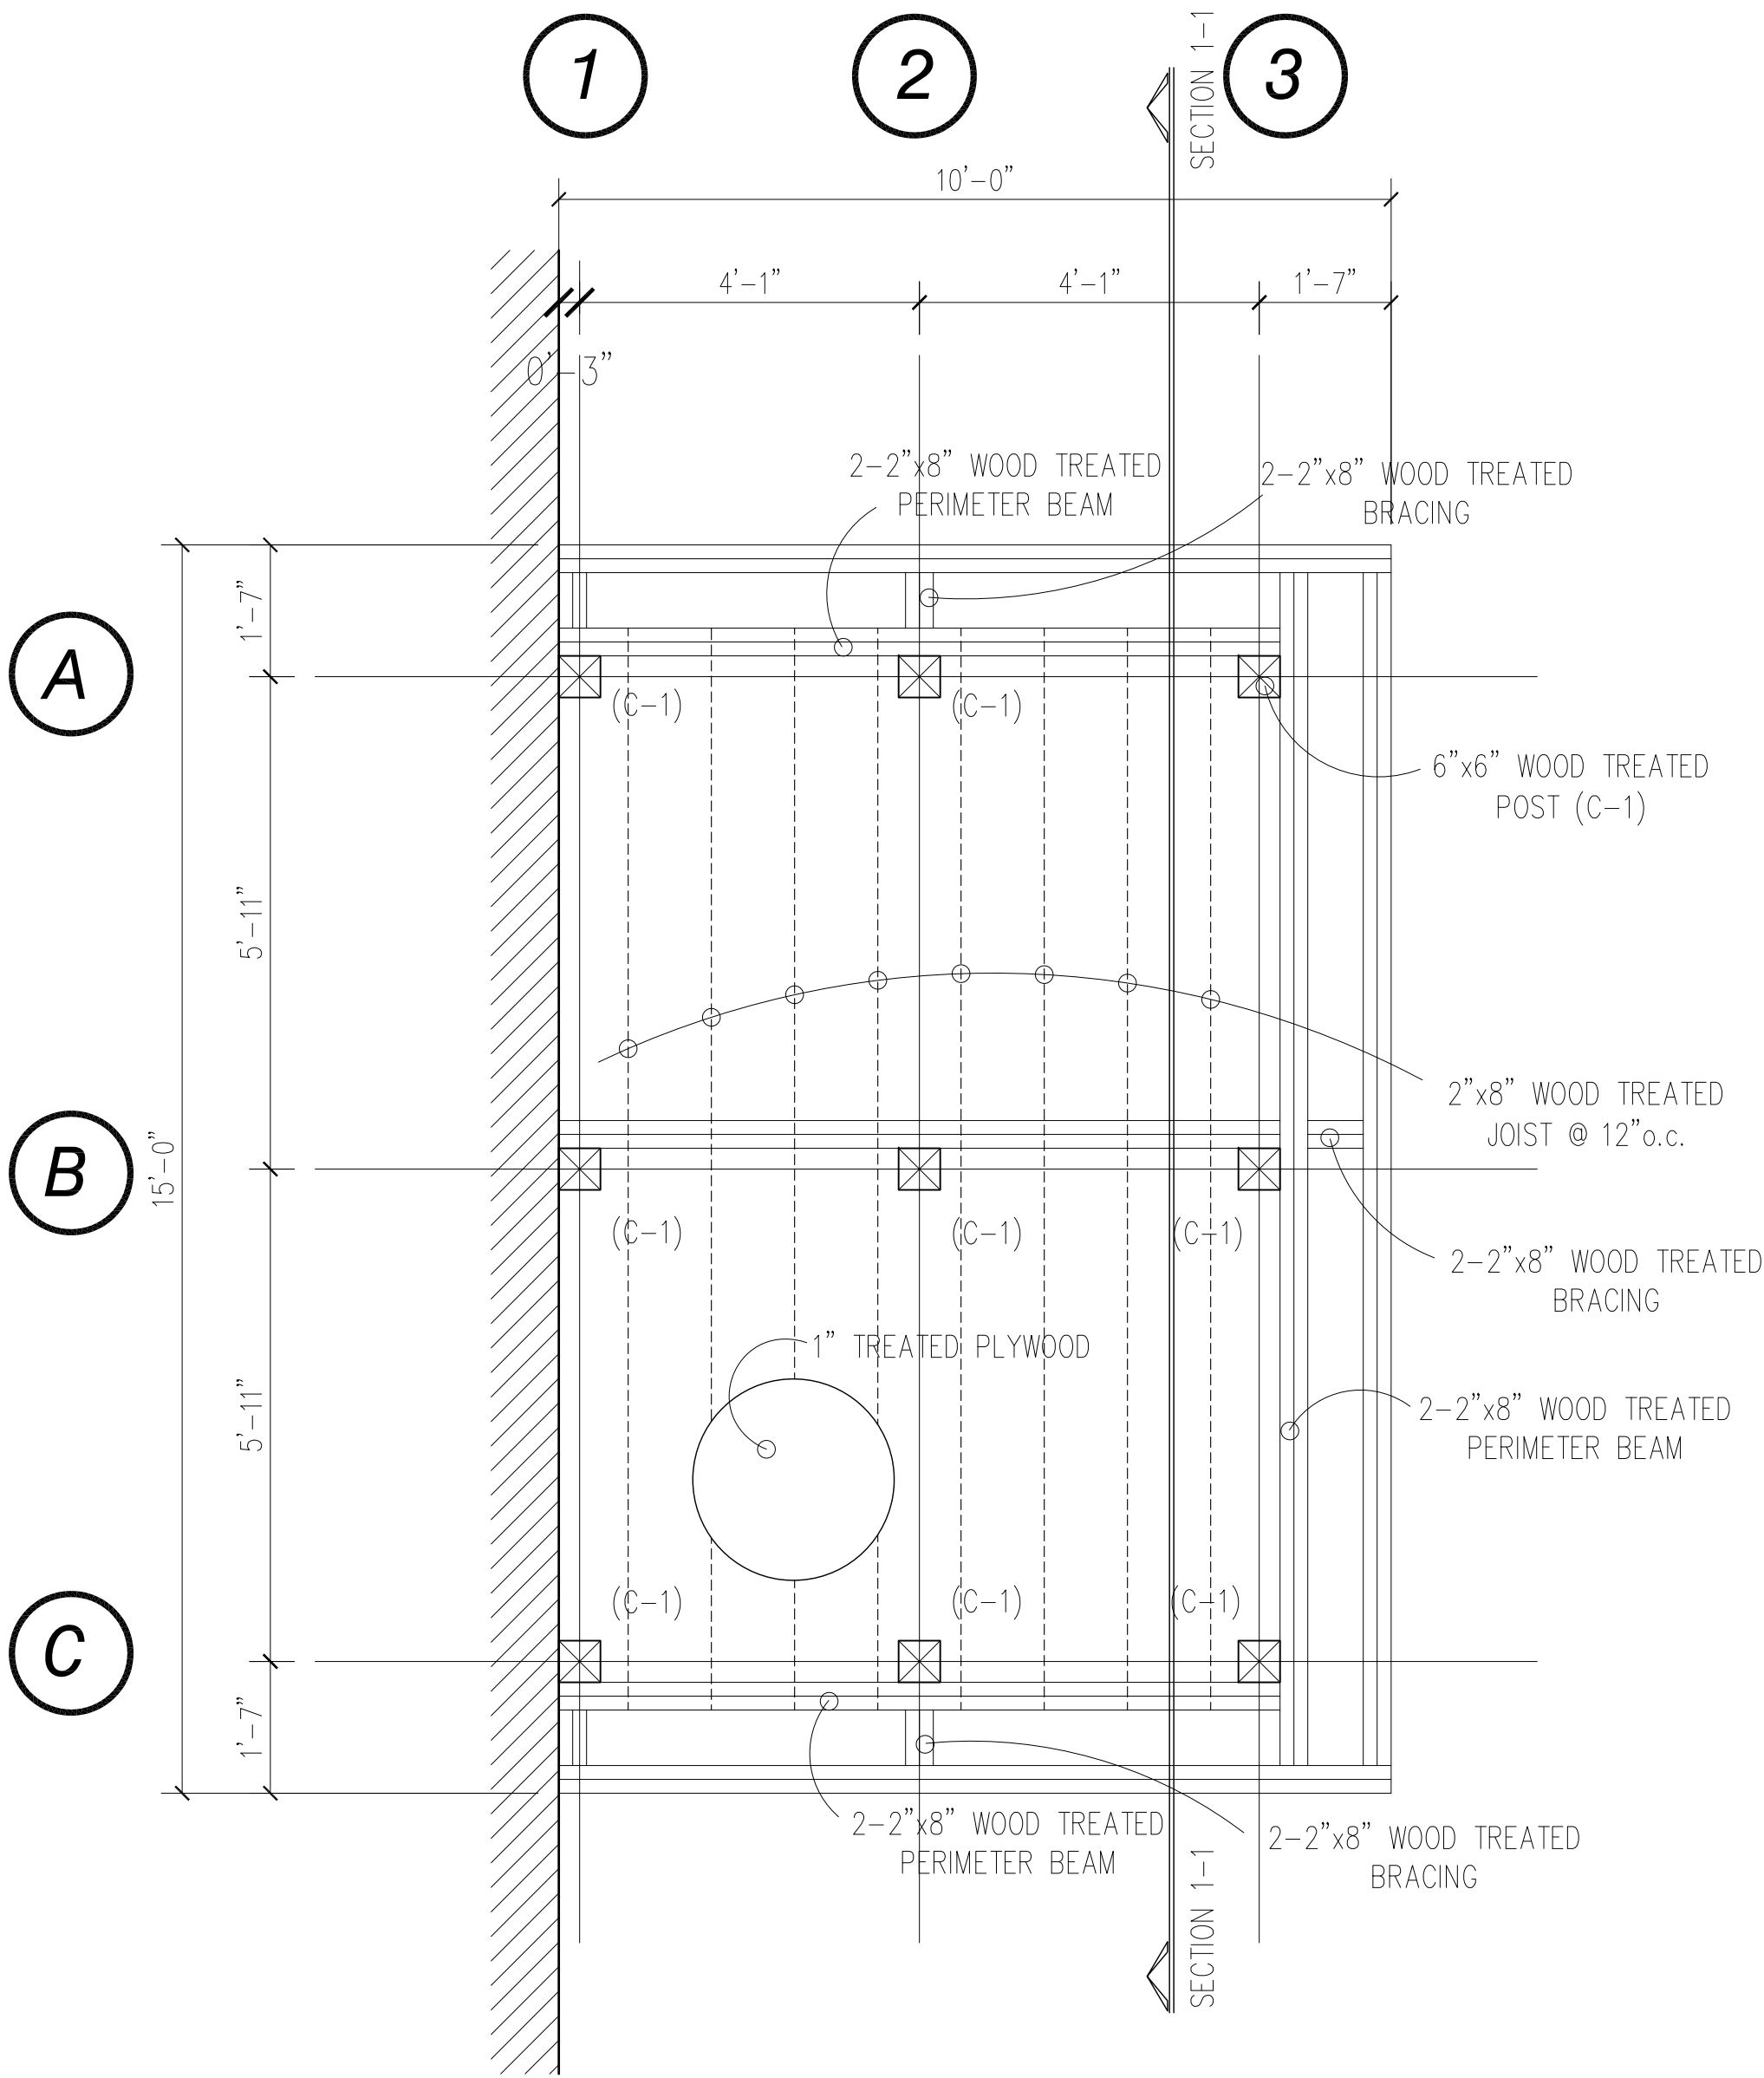


FRAMING PLAN

STAGE SCALE : 1/2" = 1'-0"

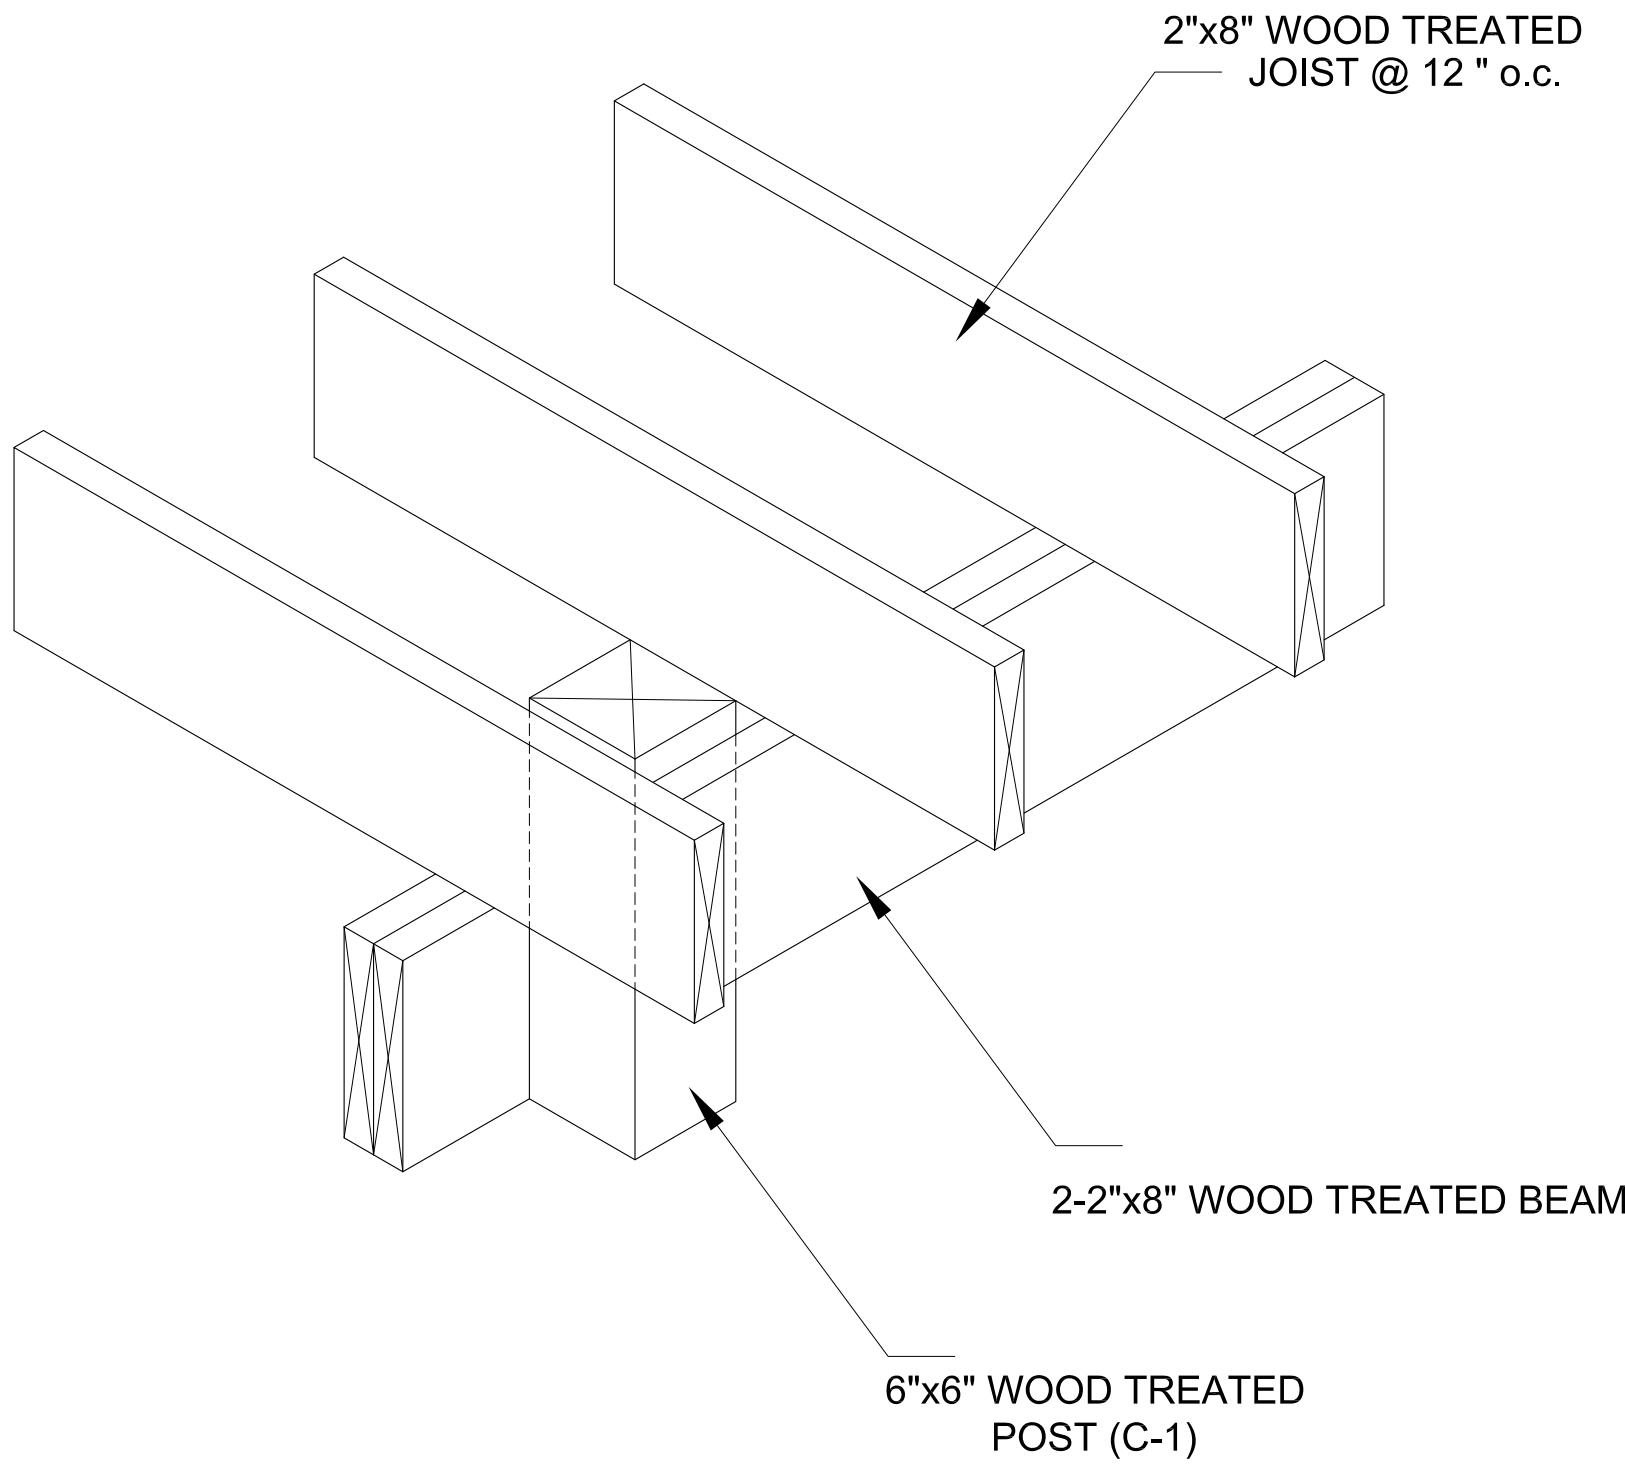


DETAIL D-1

NOT TO SCALE

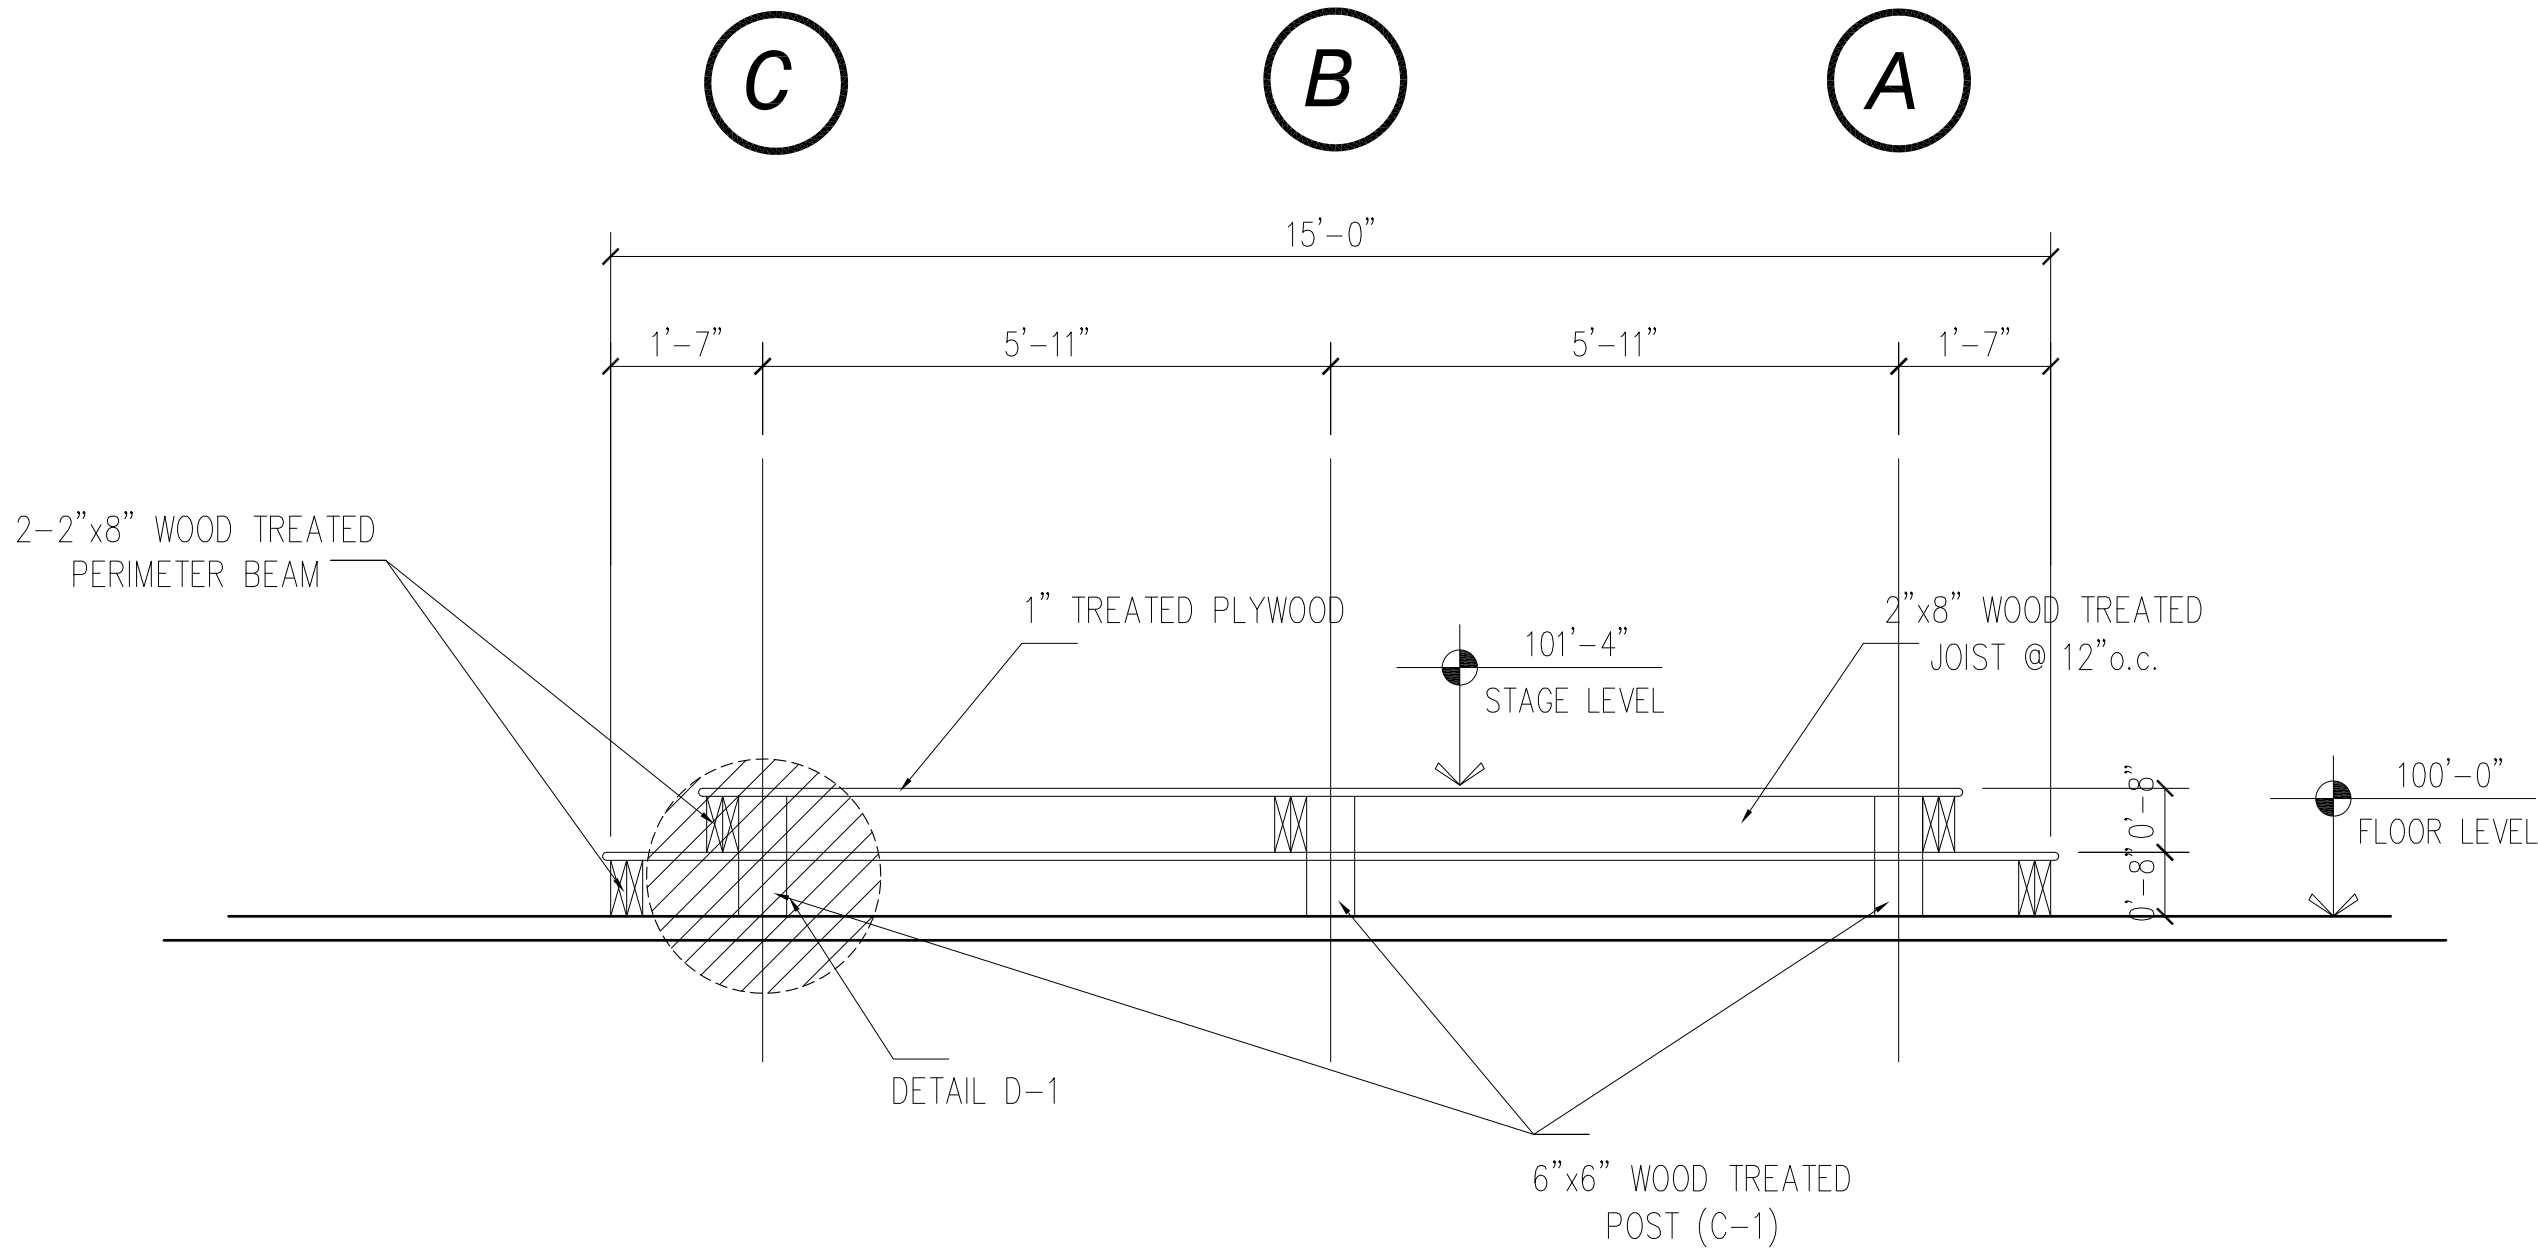


SECTION 1-1

SCALE : 1/2" = 1'-0"

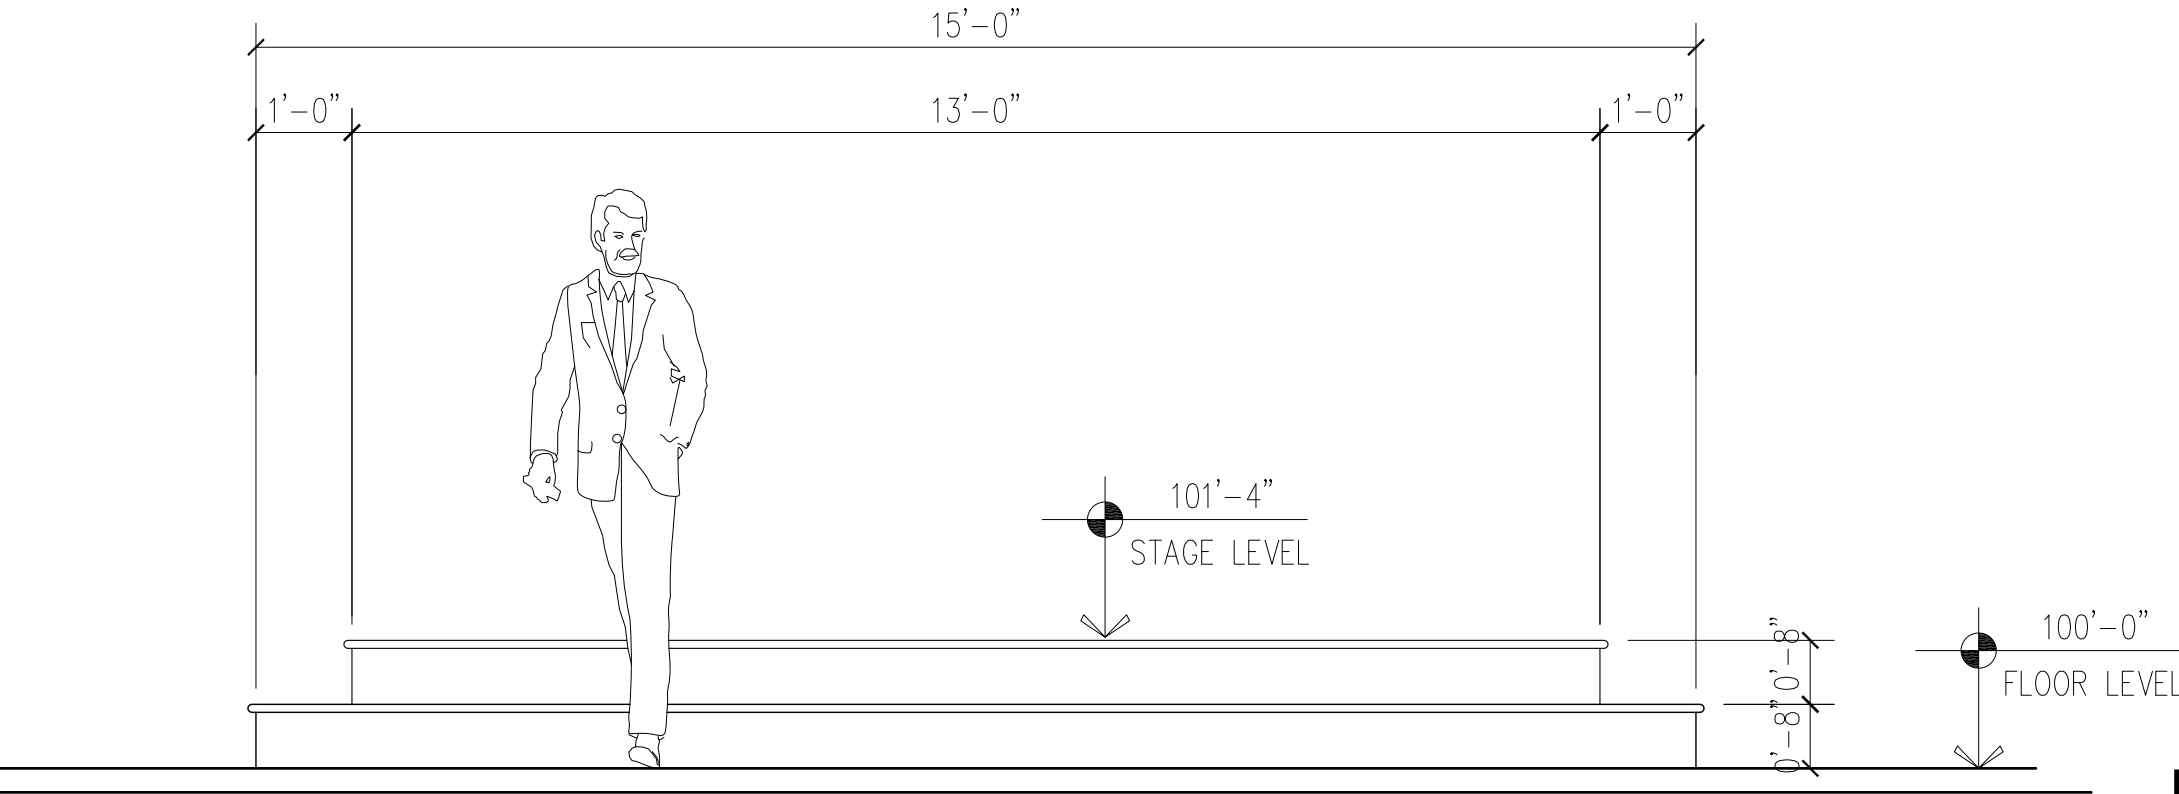

FRONT ELEVATION

STAGE SCALE : 1/2" = 1'-0"

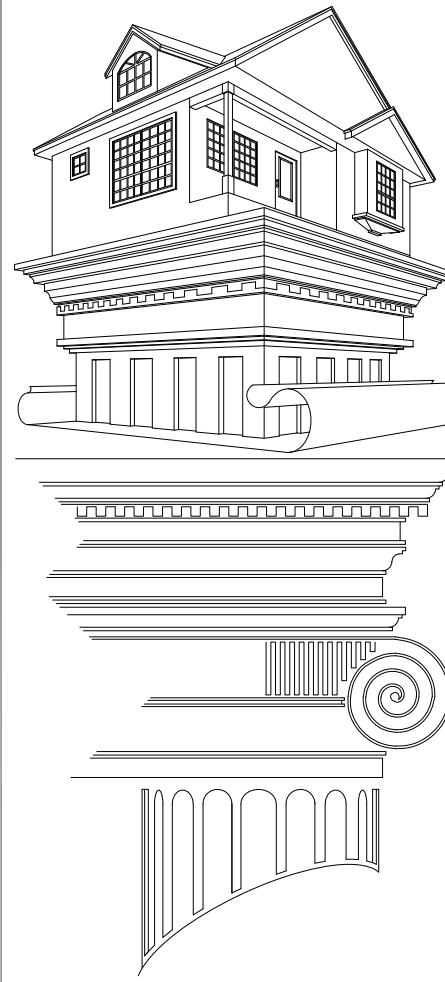

Martinez Design, LLC

Tel. : 972-891-4160


Tel. : 972-871-2512

martinezbd73@hotmail.com

GENERAL NOTES

1. THE GENERAL CONTRACTOR/BUILDER SHALL EXAMINE AND VERIFY THE ACCURACY OF ALL DIMENSIONS AND CONDITIONS OF THESE PLANS/DOCUMENTS. THE CONTRACTOR SHALL ALSO NOTIFY THE OWNER IF THERE ARE ANY DISCREPANCIES AND/OR OMISSIONS PRIOR TO THE BEGINNING OF THE CONSTRUCTION.
2. THESE PLANS ARE INTENDED FOR THE GENERAL COMMERCIAL CONSTRUCTION PURPOSES ONLY AND ARE NOT EXHAUSTIVELY DETAILED OR FULLY SPECIFIED.
3. THE GENERAL CONTRACTOR SHALL SUPERVISE THE CONSTRUCTION AND SHALL BE HIS/HER RESPONSIBILITY TO SELECT, VERIFY, RESOLVE, AND INSTALL ALL EQUIPMENT AND MATERIALS AS WELL AS TO CONTROL THE QUALITY OF THE PROJECT.
4. ALL WORK PERFORMED ON THIS PROJECT SHALL MEET OR EXCEED THE CURRENT EDITION OF THE UNIFORM BUILDING CODE AND ALL APPLICABLE STATE AND LOCAL ORDINANCES, CODE, AND REGULATIONS.
5. IT IS THE RESPONSIBILITY OF THE GENERAL CONTRACTOR TO PROVIDE ANY ENGINEERING NECESSARY TO THE STABILITY OF THE STRUCTURE(S) OF THE PROJECT. FURTHERMORE IT RECOMMENDS THAT THESE PLANS SHALL BE REVIEWED BY A QUALIFIED PROFESSIONAL ENGINEER AND TOPOGRAPHIC SPECIALIST

SQUARE FOOTAGE

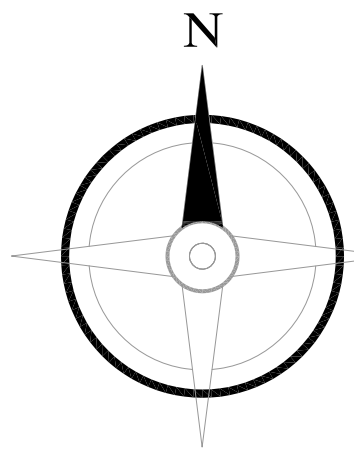

Project Name:

EXISTING RESTAURANT
INTERIOR REMODEL

Project Address:

900 W AIRPORT FWY
HURST, TX 76054

Plan Name:

STAGE PLAN

Project #:

100724

Drawn By:

JAM

Date:

10-07-2024

Scale:


3/16" = 1'-0"

Sheet #:

5

Of:


7

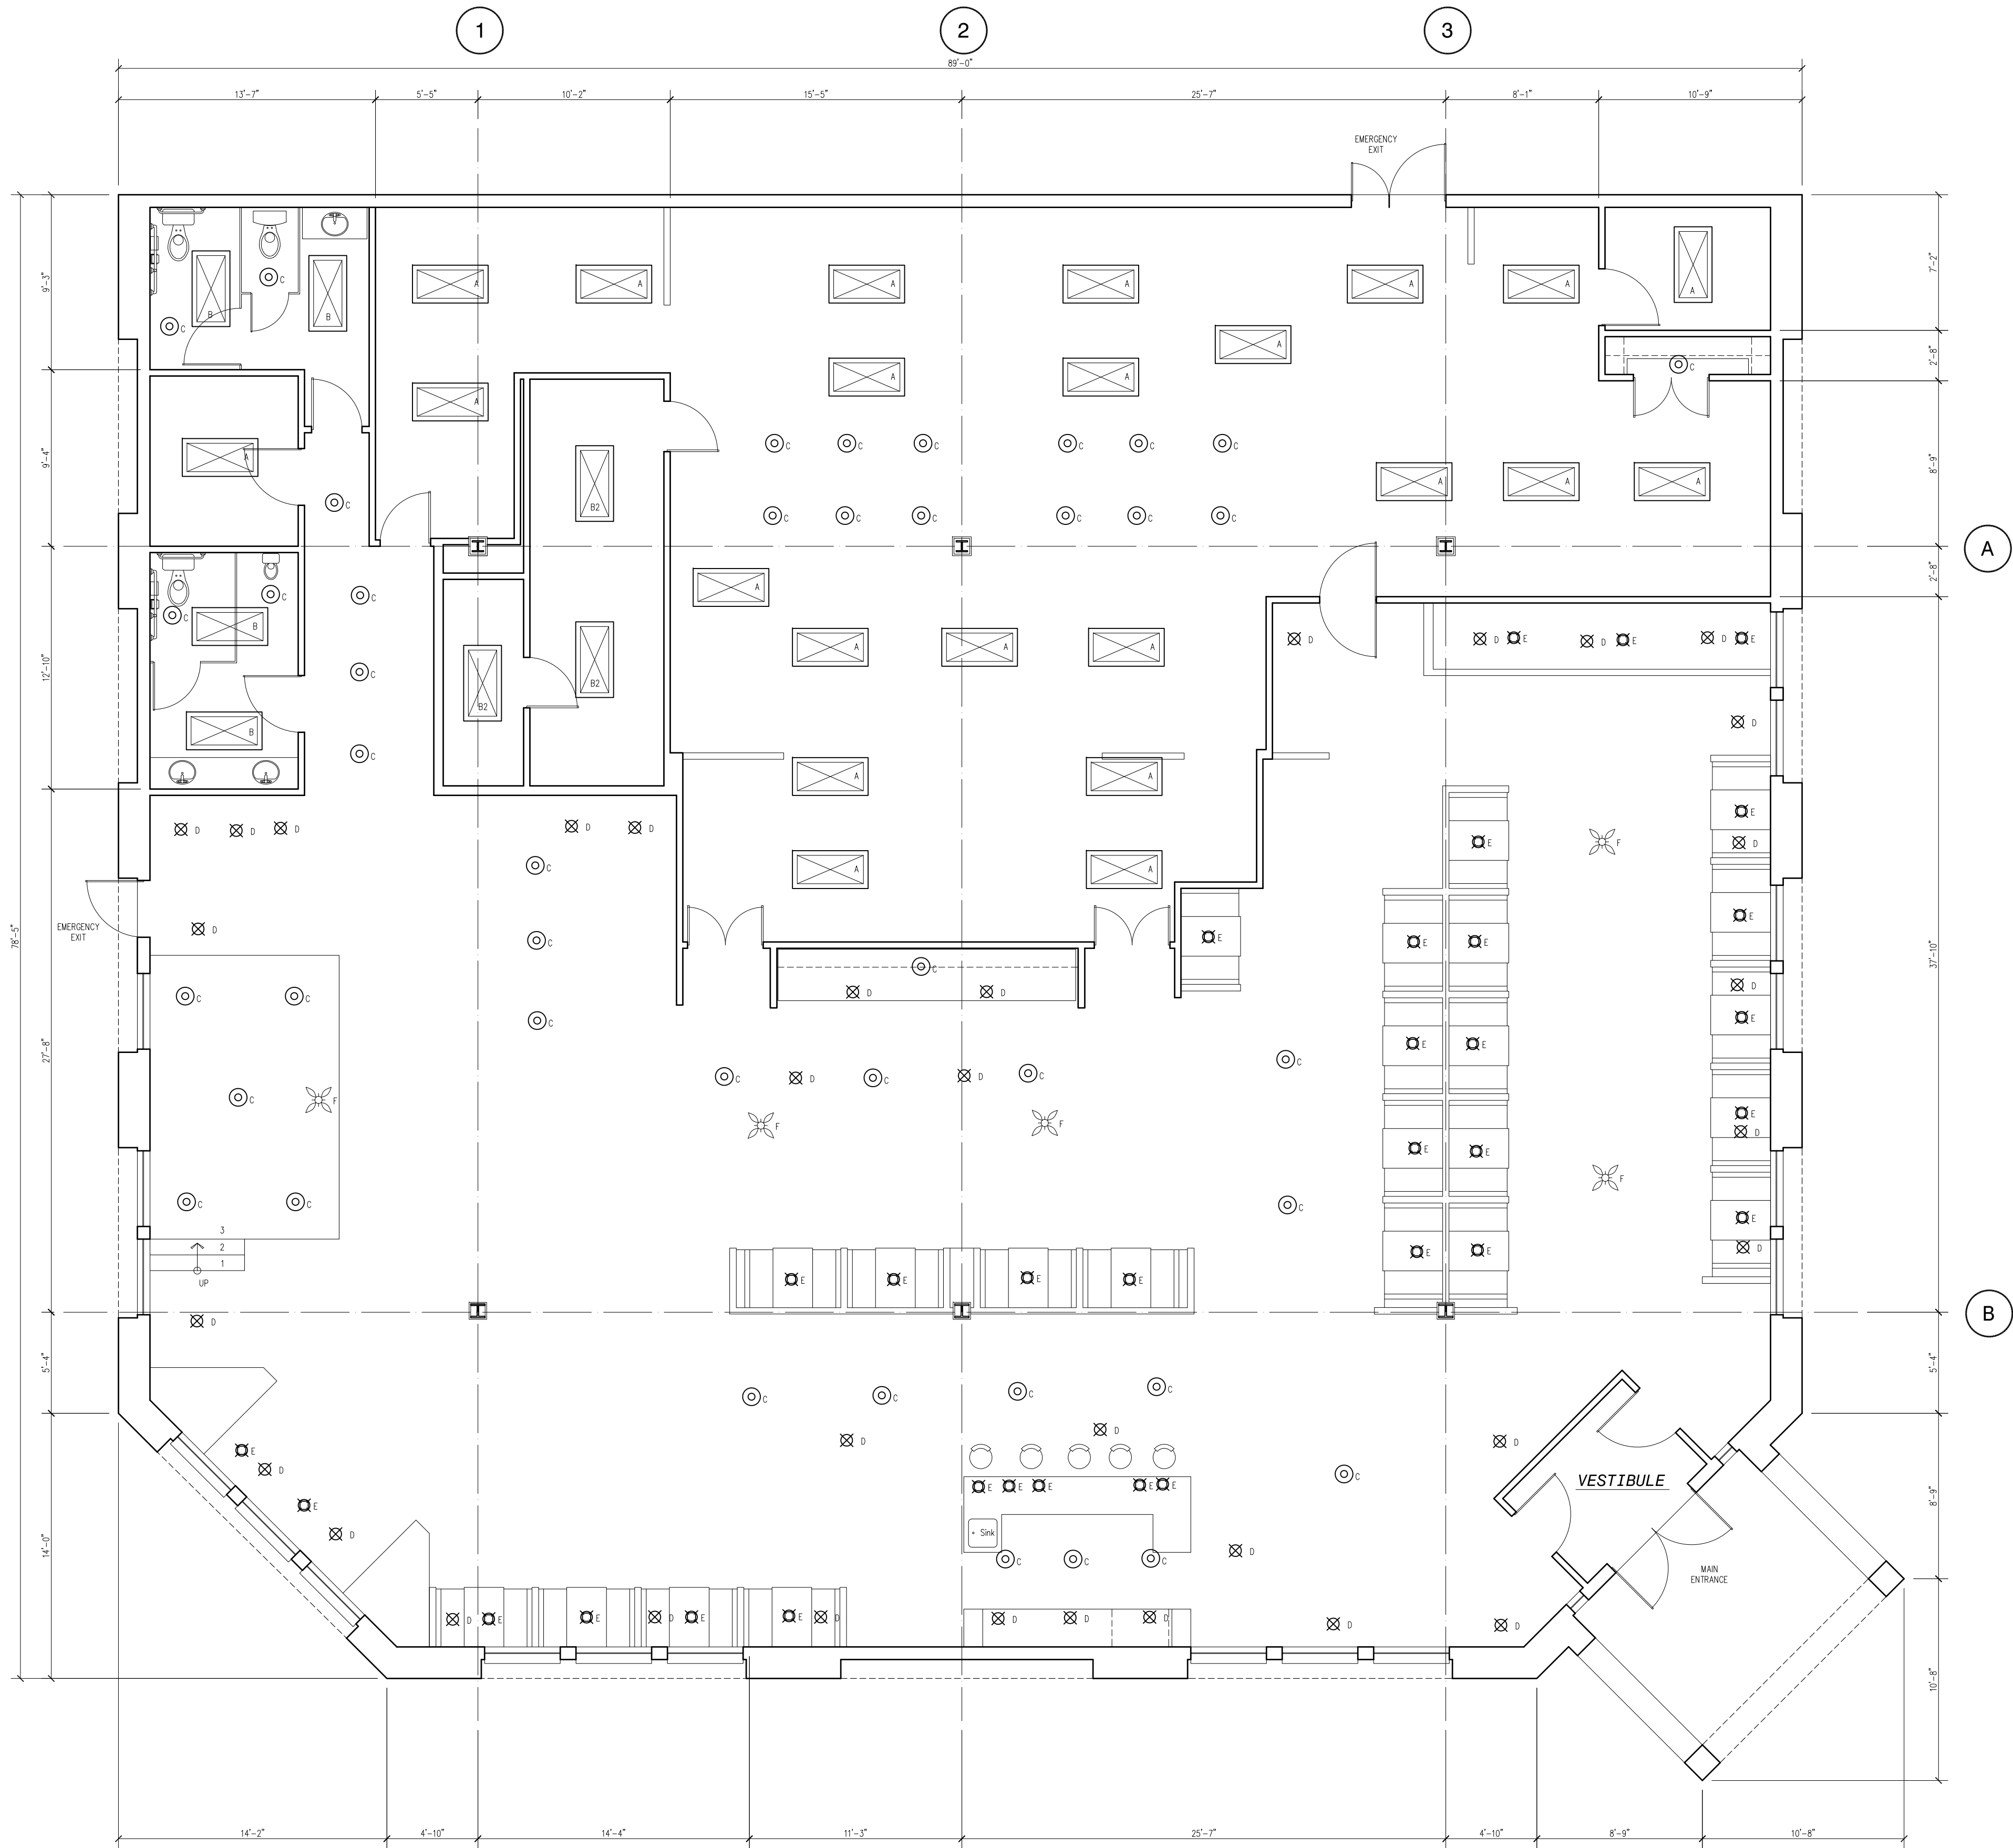

LIGHTING PLAN

SCALE : 3/16" = 1'-0"

	23	24"x48" (4 BULB FLUORESCENT LIGHT)
	4	24"x48" (2 BULB FLUORESCENT LIGHT)
	3	24"x48" (WATER PROOF 2 BULB FLUOR. LIGHT)
	43	6" DIAM. CAN LIGHT
	34	4" RECESSED LIGHT
	33	SUSPENDED LIGHT
	5	CEILING FAN / LIGHT

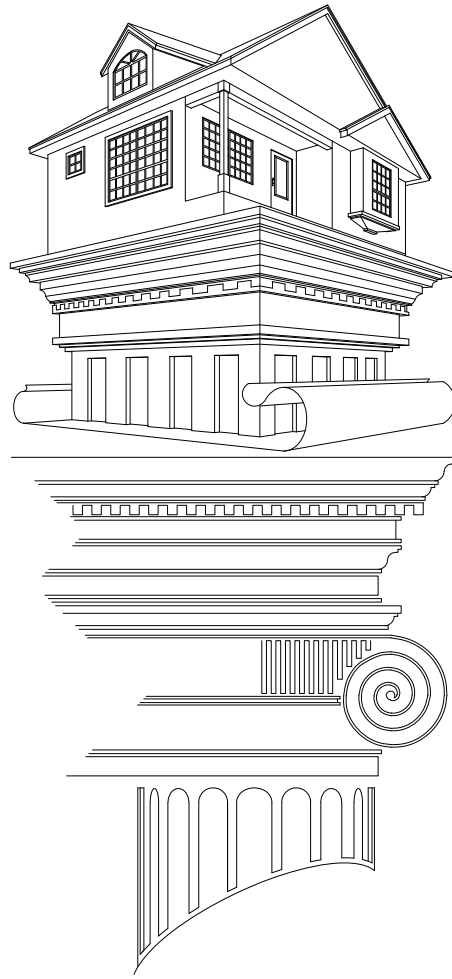

Martinez Design, LLC

Tel. : 972-891-4160


Tel. : 972-871-2512

martinezb73@hotmail.com

GENERAL NOTES

1. THE GENERAL CONTRACTOR/BUILDER SHALL EXAMINE AND VERIFY THE ACCURACY OF ALL DIMENSIONS AND CONDITIONS OF THESE PLANS/DOCUMENTS. THE CONTRACTOR SHALL ALSO NOTIFY THE OWNER IF THERE ARE ANY DISCREPANCIES AND/OR OMISSIONS PRIOR TO THE BEGINNING OF THE CONSTRUCTION.
2. THESE PLANS ARE INTENDED FOR THE GENERAL COMMERCIAL CONSTRUCTION PURPOSES ONLY AND ARE NOT EXHAUSTIVELY DETAILED OR FULLY SPECIFIED.
3. THE GENERAL CONTRACTOR SHALL SUPERVISE THE CONSTRUCTION AND SHALL BE HIS/HER RESPONSIBILITY TO SELECT, VERIFY, RESOLVE, AND INSTALL ALL EQUIPMENT AND MATERIALS AS WELL AS TO CONTROL THE QUALITY OF THE PROJECT.
4. ALL WORK PERFORMED ON THIS PROJECT SHALL MEET OR EXCEED THE CURRENT EDITION OF THE UNIFORM BUILDING CODE AND ALL APPLICABLE STATE AND LOCAL ORDINANCES, CODE, AND REGULATIONS.
5. IT IS THE RESPONSIBILITY OF THE GENERAL CONTRACTOR TO PROVIDE ANY ENGINEERING NECESSARY TO THE STABILITY OF THE STRUCTURE(S) OF THE PROJECT. FURTHERMORE IT RECOMMENDS THAT THESE PLANS SHALL BE REVIEWED BY A QUALIFIED PROFESSIONAL ENGINEER AND TOPOGRAPHIC SPECIALIST

SQUARE FOOTAGE

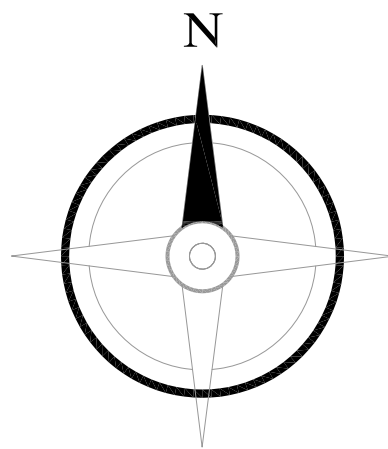

Project Name:

EXISTING RESTAURANT
INTERIOR REMODEL

Project Address:

900 W AIRPORT FWY
HURST, TX 76054

Plan Name:

LIGHTING PLAN

Project #:

100724

Drawn By:

JAM

Date:

10-07-2024

Scale:


3/16" = 1'-0"

Sheet #:

4

Of:

7

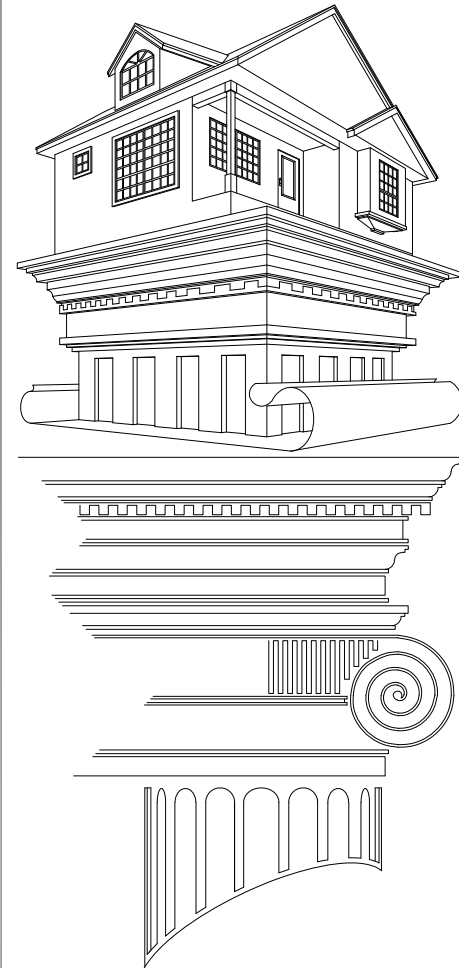

Martinez Design, LLC

Tel. : 972-891-4160

Tel. : 972-871-2512

martinezbd73@hotmail.com

GENERAL NOTES

1. THE GENERAL CONTRACTOR/BUILDER SHALL EXAMINE AND VERIFY THE ACCURACY OF ALL DIMENSIONS AND CONDITIONS OF THESE PLANS/DOCUMENTS. THE CONTRACTOR SHALL ALSO NOTIFY THE OWNER IF THERE ARE ANY DISCREPANCIES AND/OR OMISSIONS PRIOR TO THE BEGINNING OF THE CONSTRUCTION.


2. THESE PLANS ARE INTENDED FOR THE GENERAL COMMERCIAL CONSTRUCTION PURPOSES ONLY AND ARE NOT EXHAUSTIVELY DETAILED OR FULLY SPECIFIED.

3. THE GENERAL CONTRACTOR SHALL SUPERVISE THE CONSTRUCTION AND SHALL BE HIS/HER RESPONSIBILITY TO SELECT, VERIFY, RESOLVE, AND INSTALL ALL EQUIPMENT AND MATERIALS AS WELL AS TO CONTROL THE QUALITY OF THE PROJECT.

4. ALL WORK PERFORMED ON THIS PROJECT SHALL MEET OR EXCEED THE CURRENT EDITION OF THE UNIFORM BUILDING CODE AND ALL APPLICABLE STATE AND LOCAL ORDINANCES, CODE, AND REGULATIONS.

5. IT IS THE RESPONSIBILITY OF THE GENERAL CONTRACTOR TO PROVIDE ANY ENGINEERING NECESSARY TO THE STABILITY OF THE STRUCTURE(S) OF THE PROJECT. FURTHERMORE IT RECOMMENDS THAT THESE PLANS SHALL BE REVIEWED BY A QUALIFIED PROFESSIONAL ENGINEER AND TOPOGRAPHIC SPECIALIST

SQUARE FOOTAGE

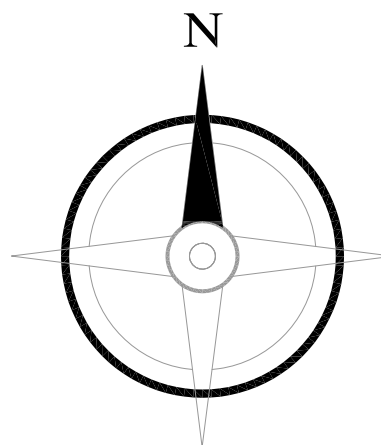

Project Name:

EXISTING RESTAURANT
INTERIOR REMODEL

Project Address:

900 W AIRPORT FWY
HURST, TX 76054

Plan Name:

NEW FLOOR PLAN

Project #:

100724

Drawn By:

JAM

Date:

10-07-2024

Scale:


3/16" = 1'-0"

Sheet #:

3


Of:

7

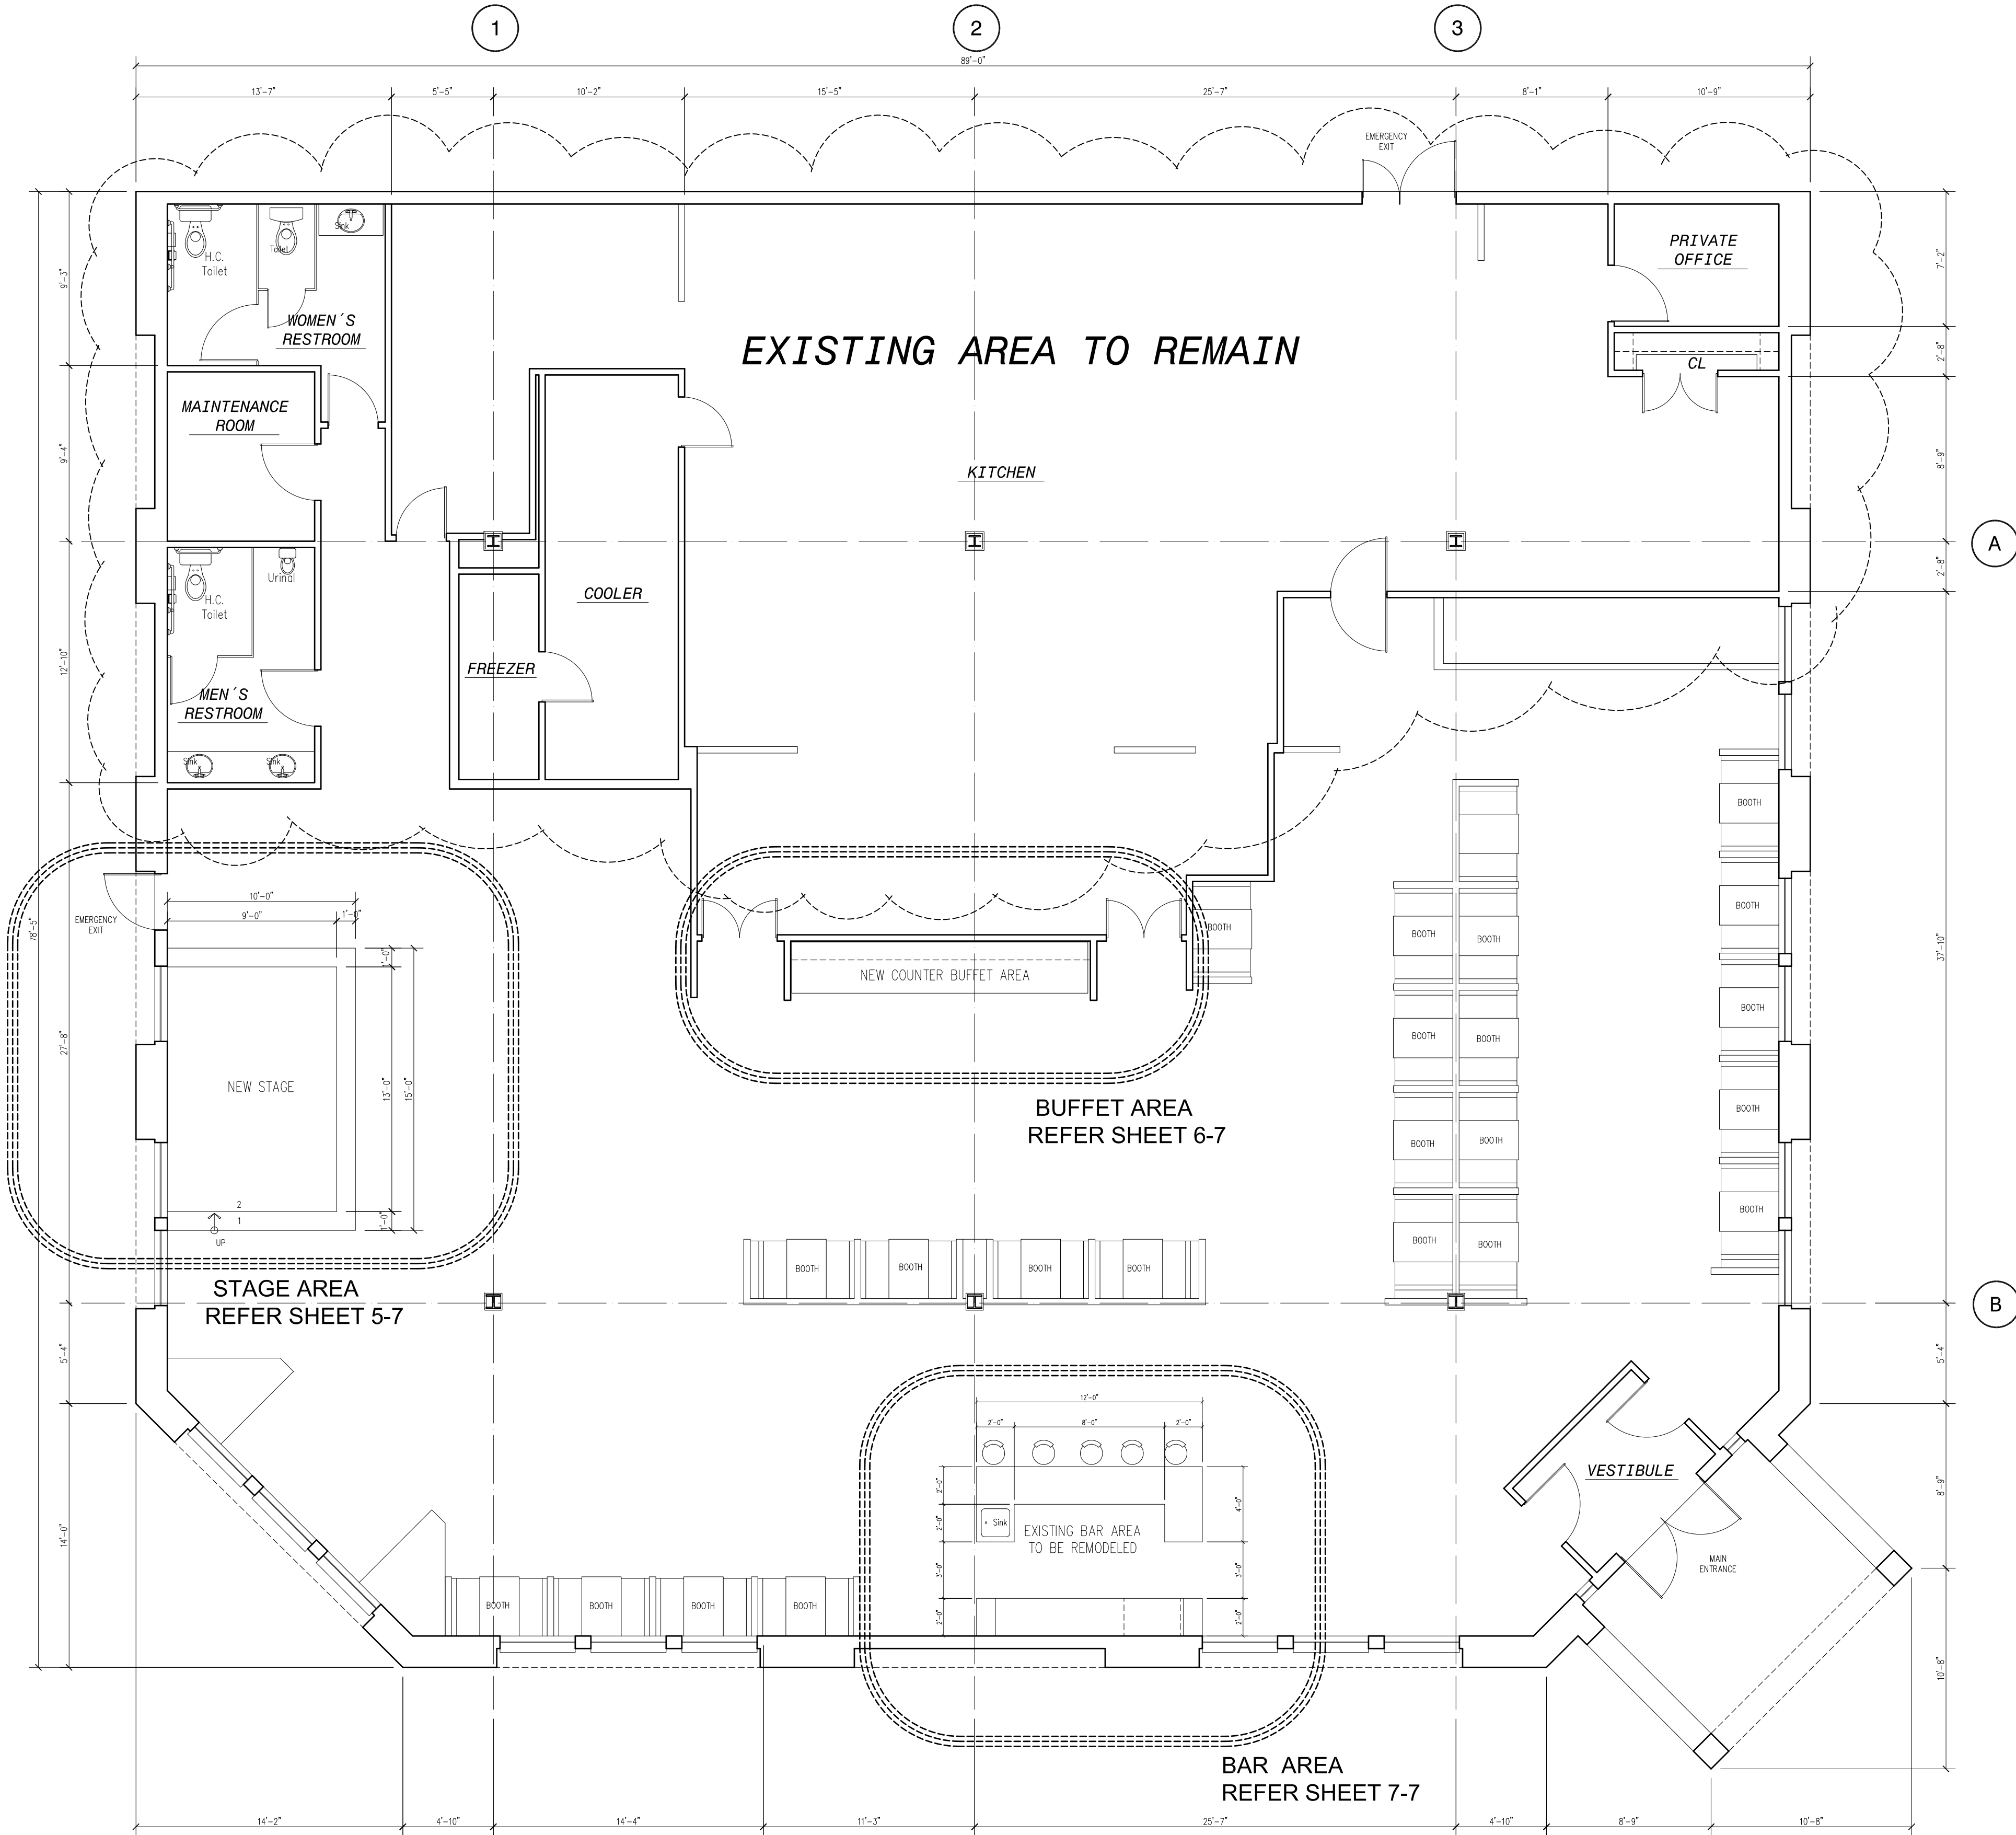


NEW FLOOR PLAN

SCALE : 3/16" = 1'-0"

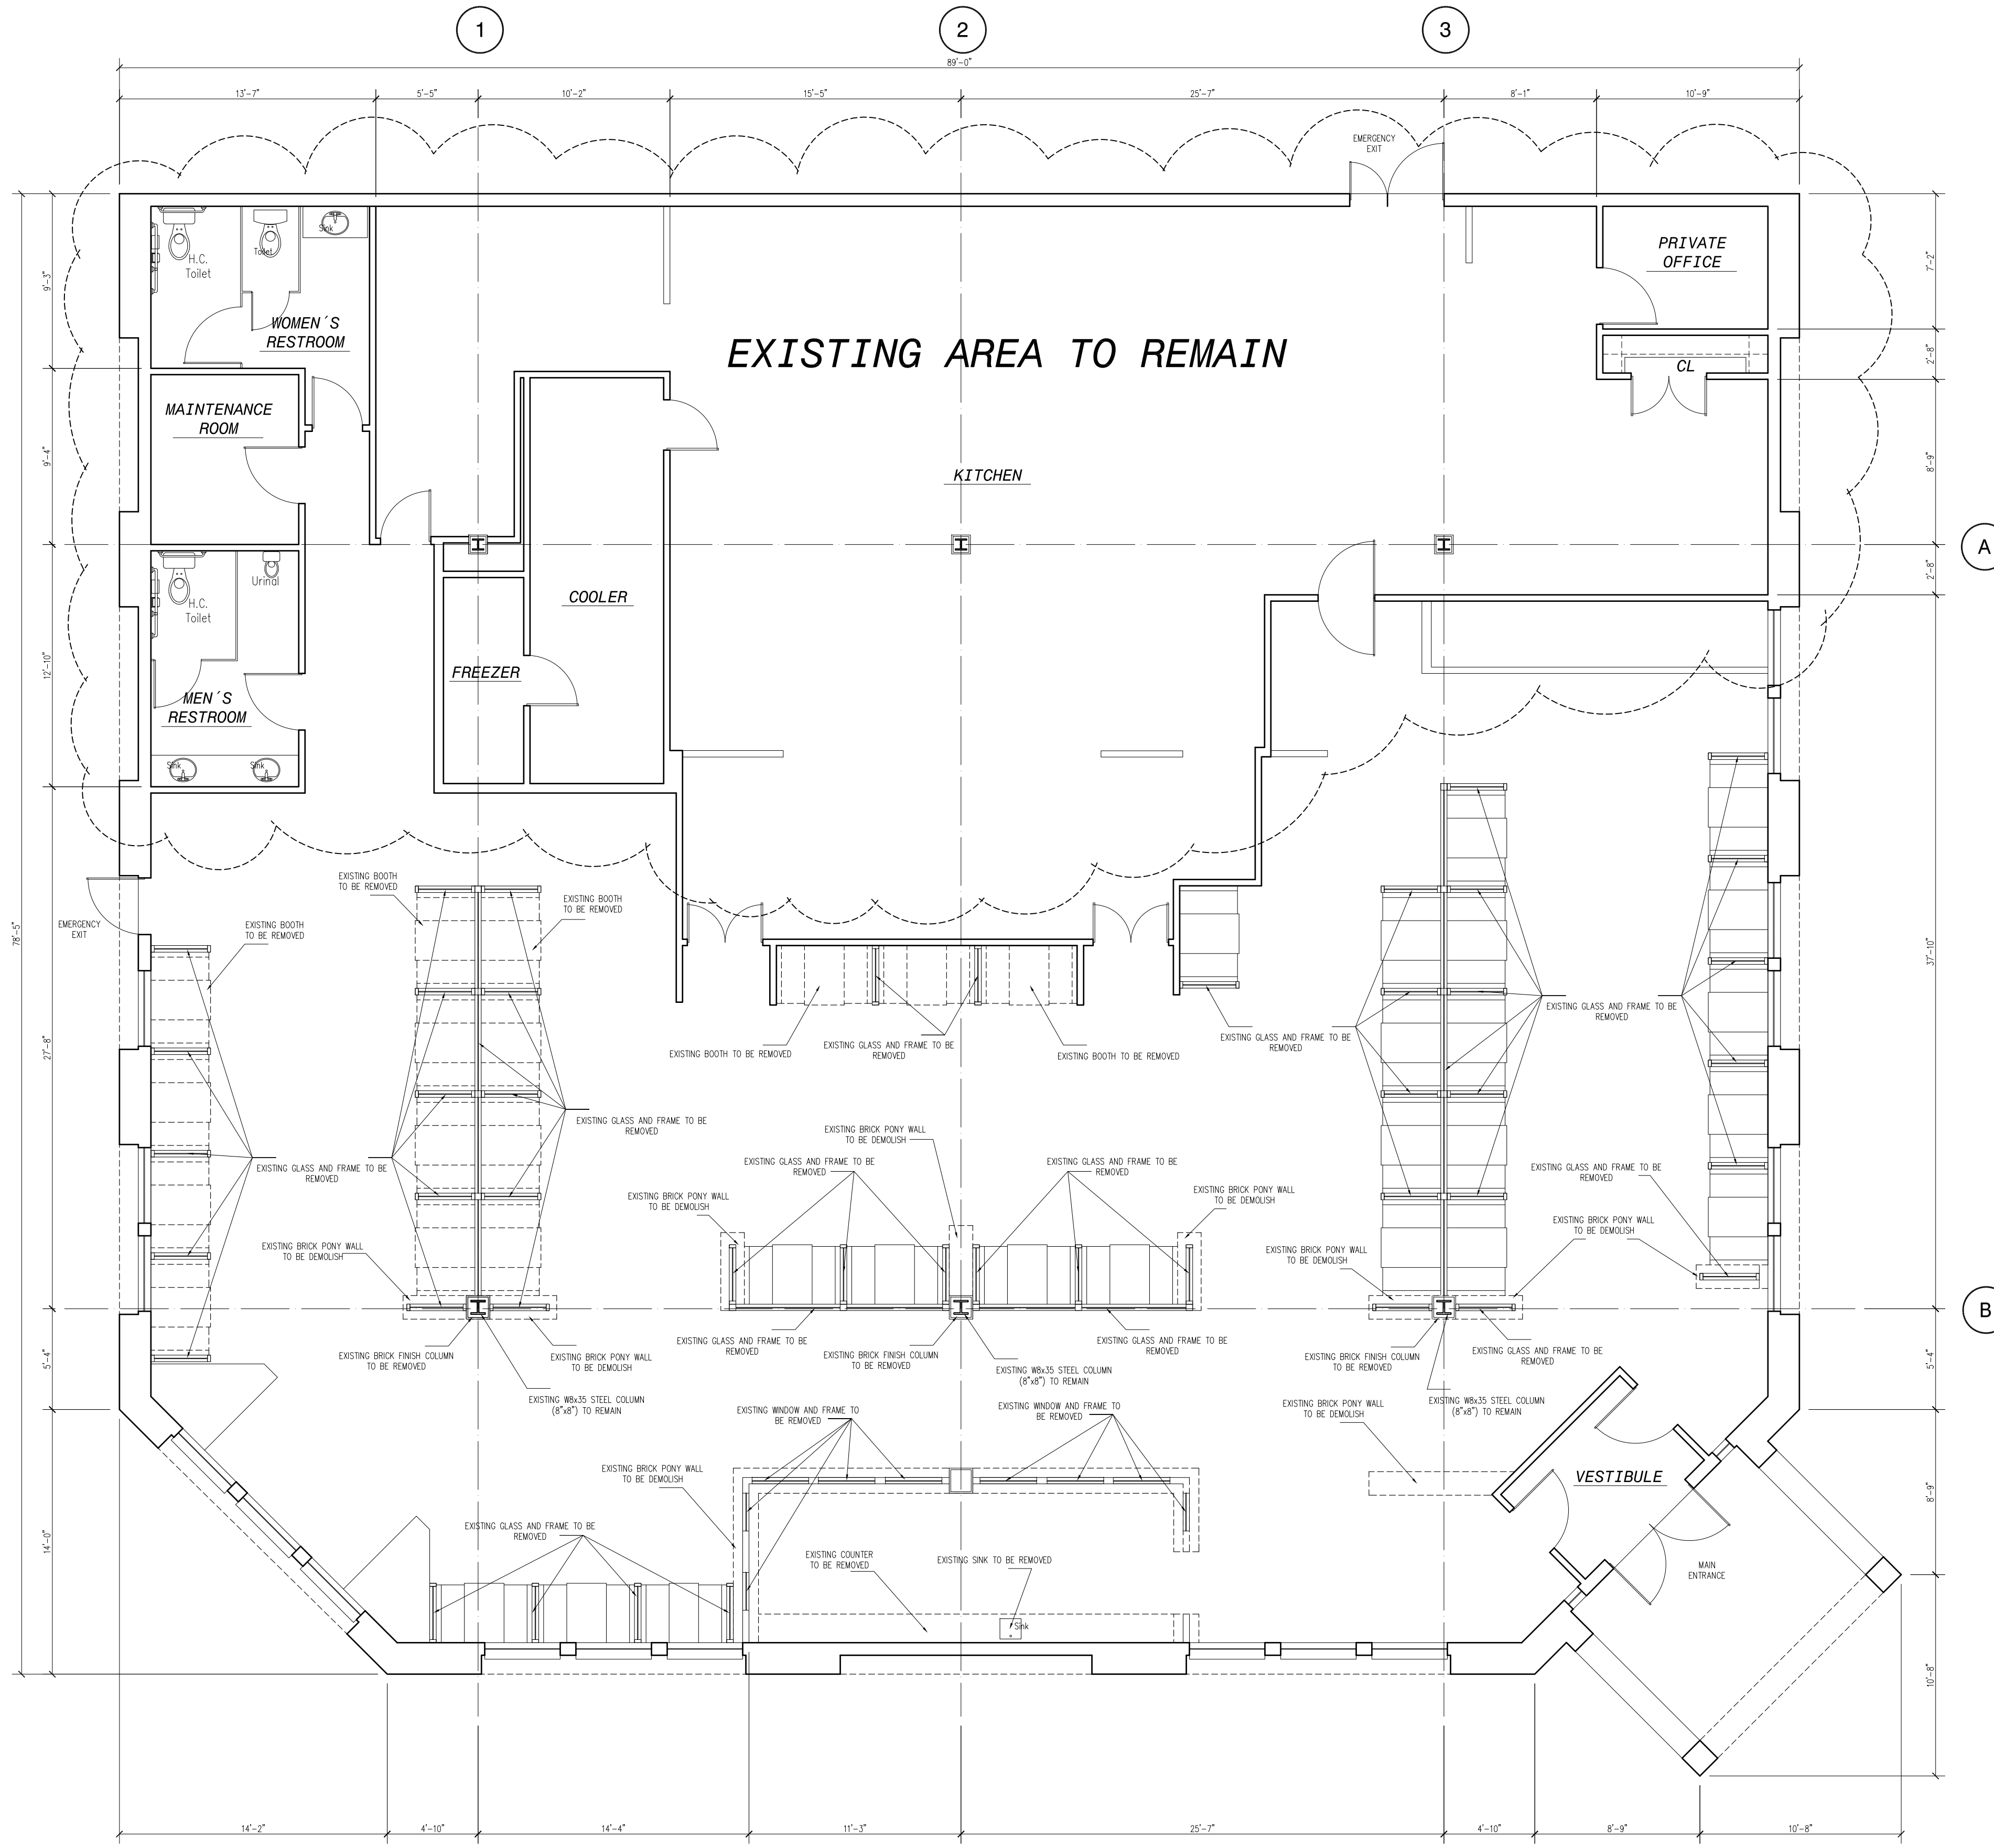

DEMO PLAN

SCALE : 3/16" = 1'-0"

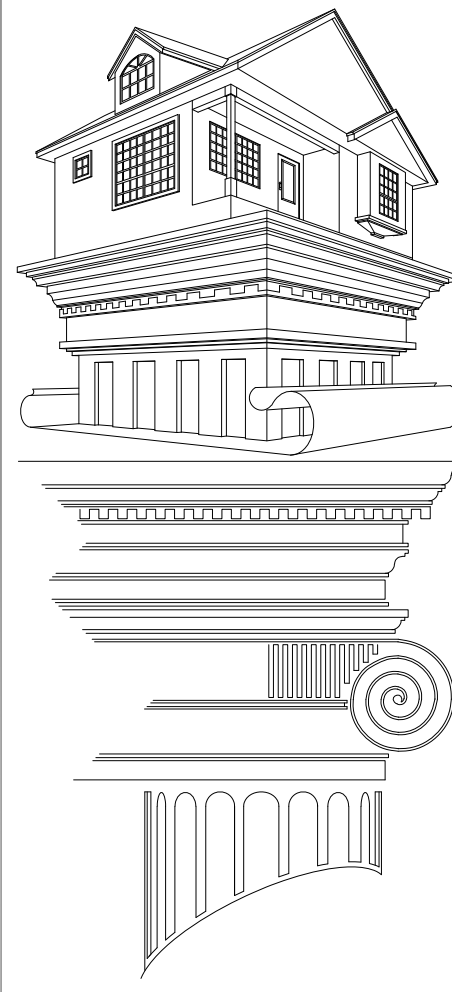


Martinez Design, LLC
Tel. : 972-891-4160
Tel. : 972-871-2512
martinezbd73@hotmail.com

GENERAL NOTES

1. THE GENERAL CONTRACTOR/BUILDER SHALL EXAMINE AND VERIFY THE ACCURACY OF ALL DIMENSIONS AND CONDITIONS OF THESE PLANS/DOCUMENTS. THE CONTRACTOR SHALL ALSO NOTIFY THE OWNER IF THERE ARE ANY DISCREPANCIES AND/OR OMISSIONS PRIOR TO THE BEGINNING OF THE CONSTRUCTION.
2. THESE PLANS ARE INTENDED FOR THE GENERAL COMMERCIAL CONSTRUCTION PURPOSES ONLY AND ARE NOT EXHAUSTIVELY DETAILED OR FULLY SPECIFIED.
3. THE GENERAL CONTRACTOR SHALL SUPERVISE THE CONSTRUCTION AND SHALL BE HIS/HER RESPONSIBILITY TO SELECT, VERIFY, RESOLVE, AND INSTALL ALL EQUIPMENT AND MATERIALS AS WELL AS TO CONTROL THE QUALITY OF THE PROJECT.
4. ALL WORK PERFORMED ON THIS PROJECT SHALL MEET OR EXCEED THE CURRENT EDITION OF THE UNIFORM BUILDING CODE AND ALL APPLICABLE STATE AND LOCAL ORDINANCES, CODE, AND REGULATIONS.
5. IT IS THE RESPONSIBILITY OF THE GENERAL CONTRACTOR TO PROVIDE ANY ENGINEERING NECESSARY TO THE STABILITY OF THE STRUCTURE(S) OF THE PROJECT. FURTHERMORE IT RECOMMENDS THAT THESE PLANS SHALL BE REVIEWED BY A QUALIFIED PROFESSIONAL ENGINEER AND TOPOGRAPHIC SPECIALIST

SQUARE FOOTAGE

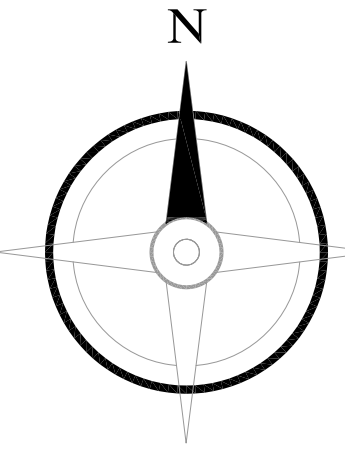

Project Name:

EXISTING RESTAURANT
INTERIOR REMODEL

Project Address:

900 W AIRPORT FWY
HURST, TX 76054

Plan Name:

DEMO PLAN

Project #:

100724

Drawn By:

JAM

Date:

10-07-2024

Scale:


3/16" = 1'-0"

Sheet #:

2

Of:

7

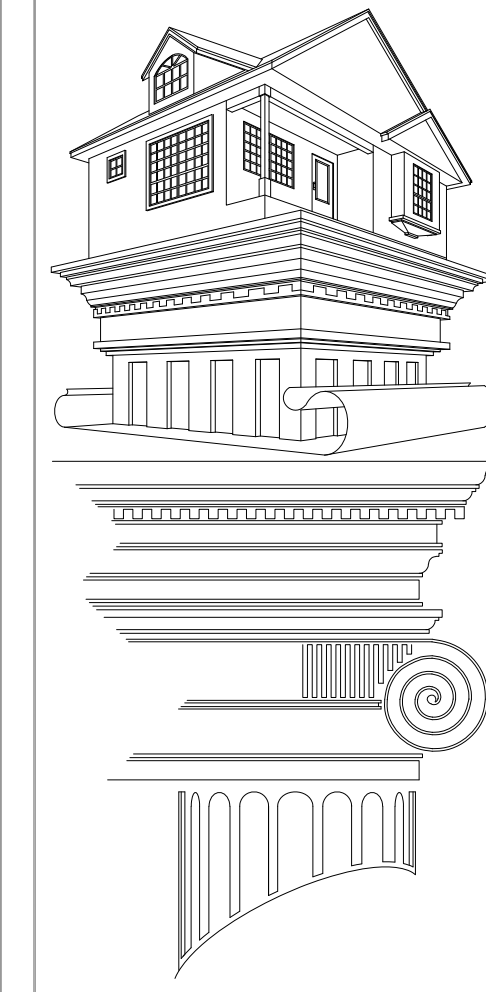


Martinez Design, LLC
Tel. : 972-891-4160
Tel. : 972-871-2512
martinezbd73@hotmail.com

GENERAL NOTES

1. THE GENERAL CONTRACTOR/BUILDER SHALL EXAMINE AND VERIFY THE ACCURACY OF ALL DIMENSIONS AND CONDITIONS OF THESE PLANS/DOCUMENTS. THE CONTRACTOR SHALL ALSO NOTIFY THE OWNER IF THERE ARE ANY DISCREPANCIES AND/OR OMISSIONS PRIOR TO THE BEGINNING OF THE CONSTRUCTION.
2. THESE PLANS ARE INTENDED FOR THE GENERAL COMMERCIAL CONSTRUCTION PURPOSES ONLY AND ARE NOT EXHAUSTIVELY DETAILED OR FULLY SPECIFIED.
3. THE GENERAL CONTRACTOR SHALL SUPERVISE THE CONSTRUCTION AND SHALL BE HIS/HER RESPONSIBILITY TO SELECT, VERIFY, RESOLVE, AND INSTALL ALL EQUIPMENT AND MATERIALS AS WELL AS TO CONTROL THE QUALITY OF THE PROJECT.
4. ALL WORK PERFORMED ON THIS PROJECT SHALL MEET OR EXCEED THE CURRENT EDITION OF THE UNIFORM BUILDING CODE AND ALL APPLICABLE STATE AND LOCAL ORDINANCES, CODE, AND REGULATIONS.
5. IT IS THE RESPONSIBILITY OF THE GENERAL CONTRACTOR TO PROVIDE ANY ENGINEERING NECESSARY TO THE STABILITY OF THE STRUCTURE(S) OF THE PROJECT. FURTHERMORE IT RECOMMENDS THAT THESE PLANS SHALL BE REVIEWED BY A QUALIFIED PROFESSIONAL ENGINEER AND TOPOGRAPHIC SPECIALIST

SQUARE FOOTAGE

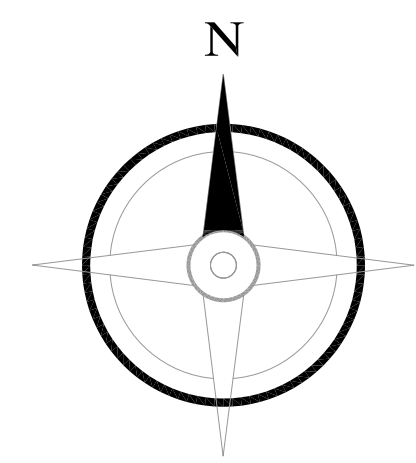

Project Name:

**EXISTING RESTAURANT
INTERIOR REMODEL**


Project Address:

**900 W AIRPORT FWY
HURST, TX 76054**

Plan Name:

EXISTING FLOOR PLAN

Project #:	100724	Drawn By:	JAM
Date:	10-07-2024	Scale:	3/16" = 1'-0"
Sheet #:	1	Of:	7

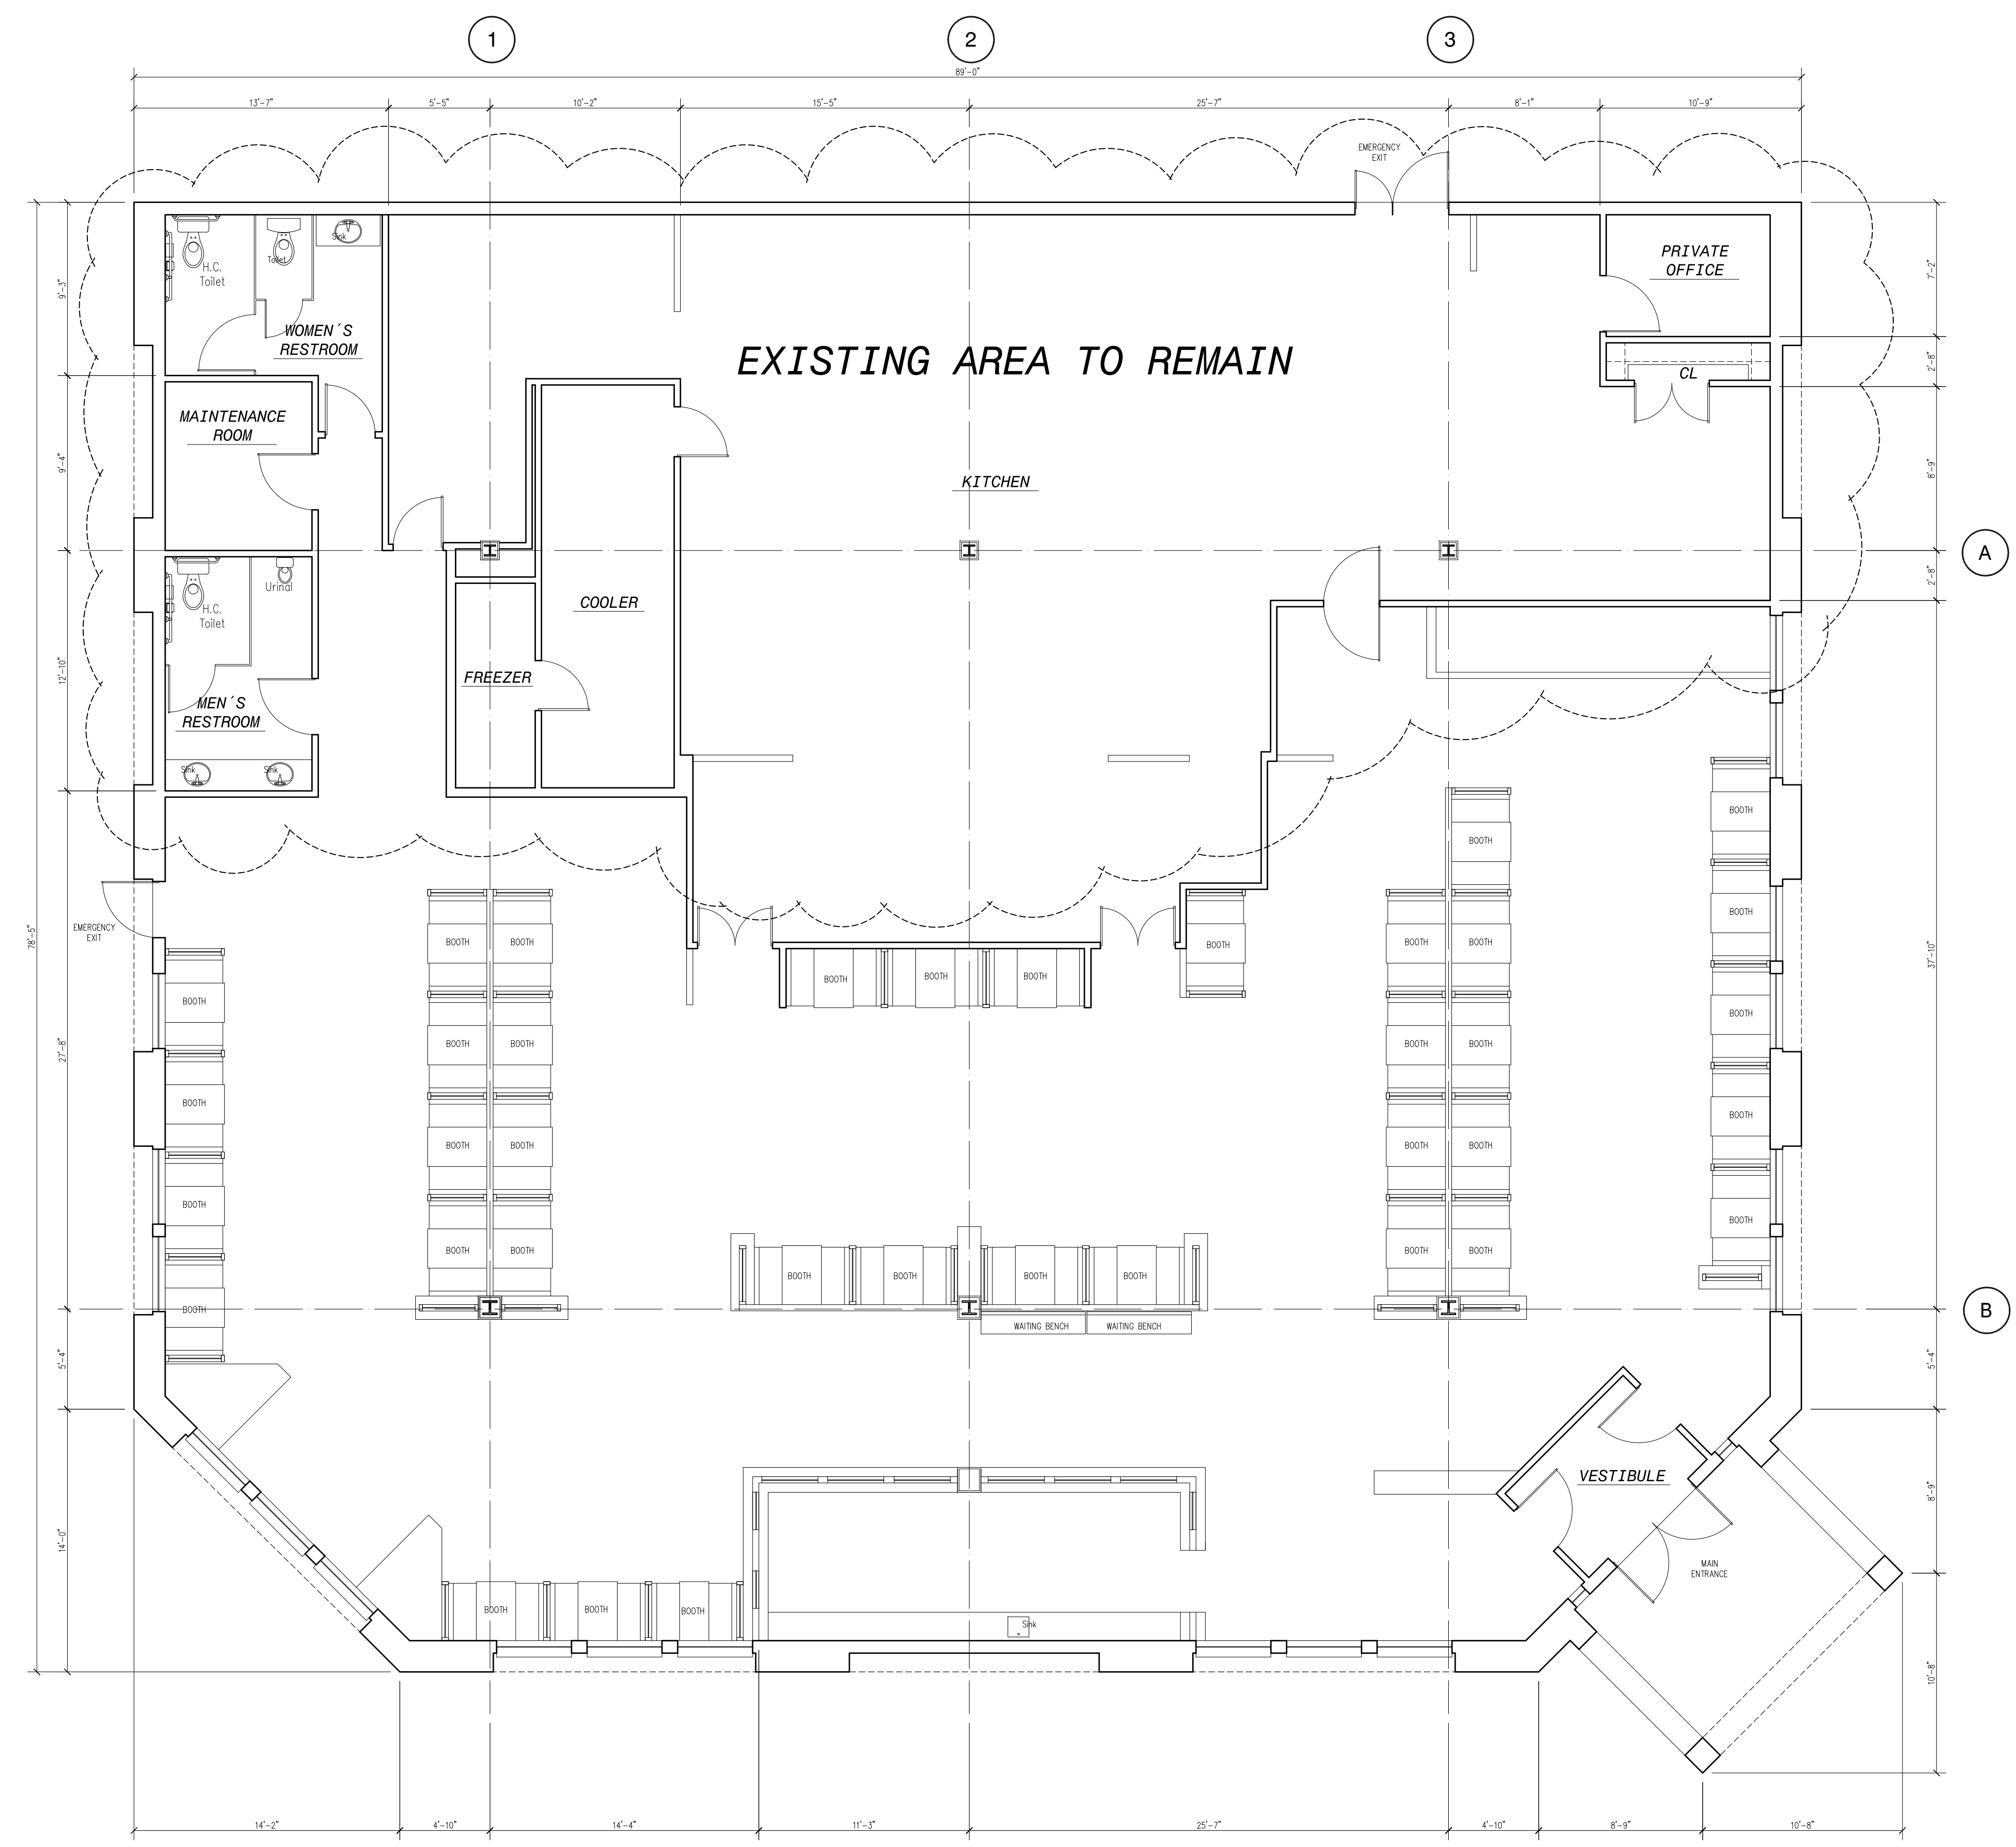

EXISTING FLOOR PLAN

SCALE : 3/16" = 1'-0"