

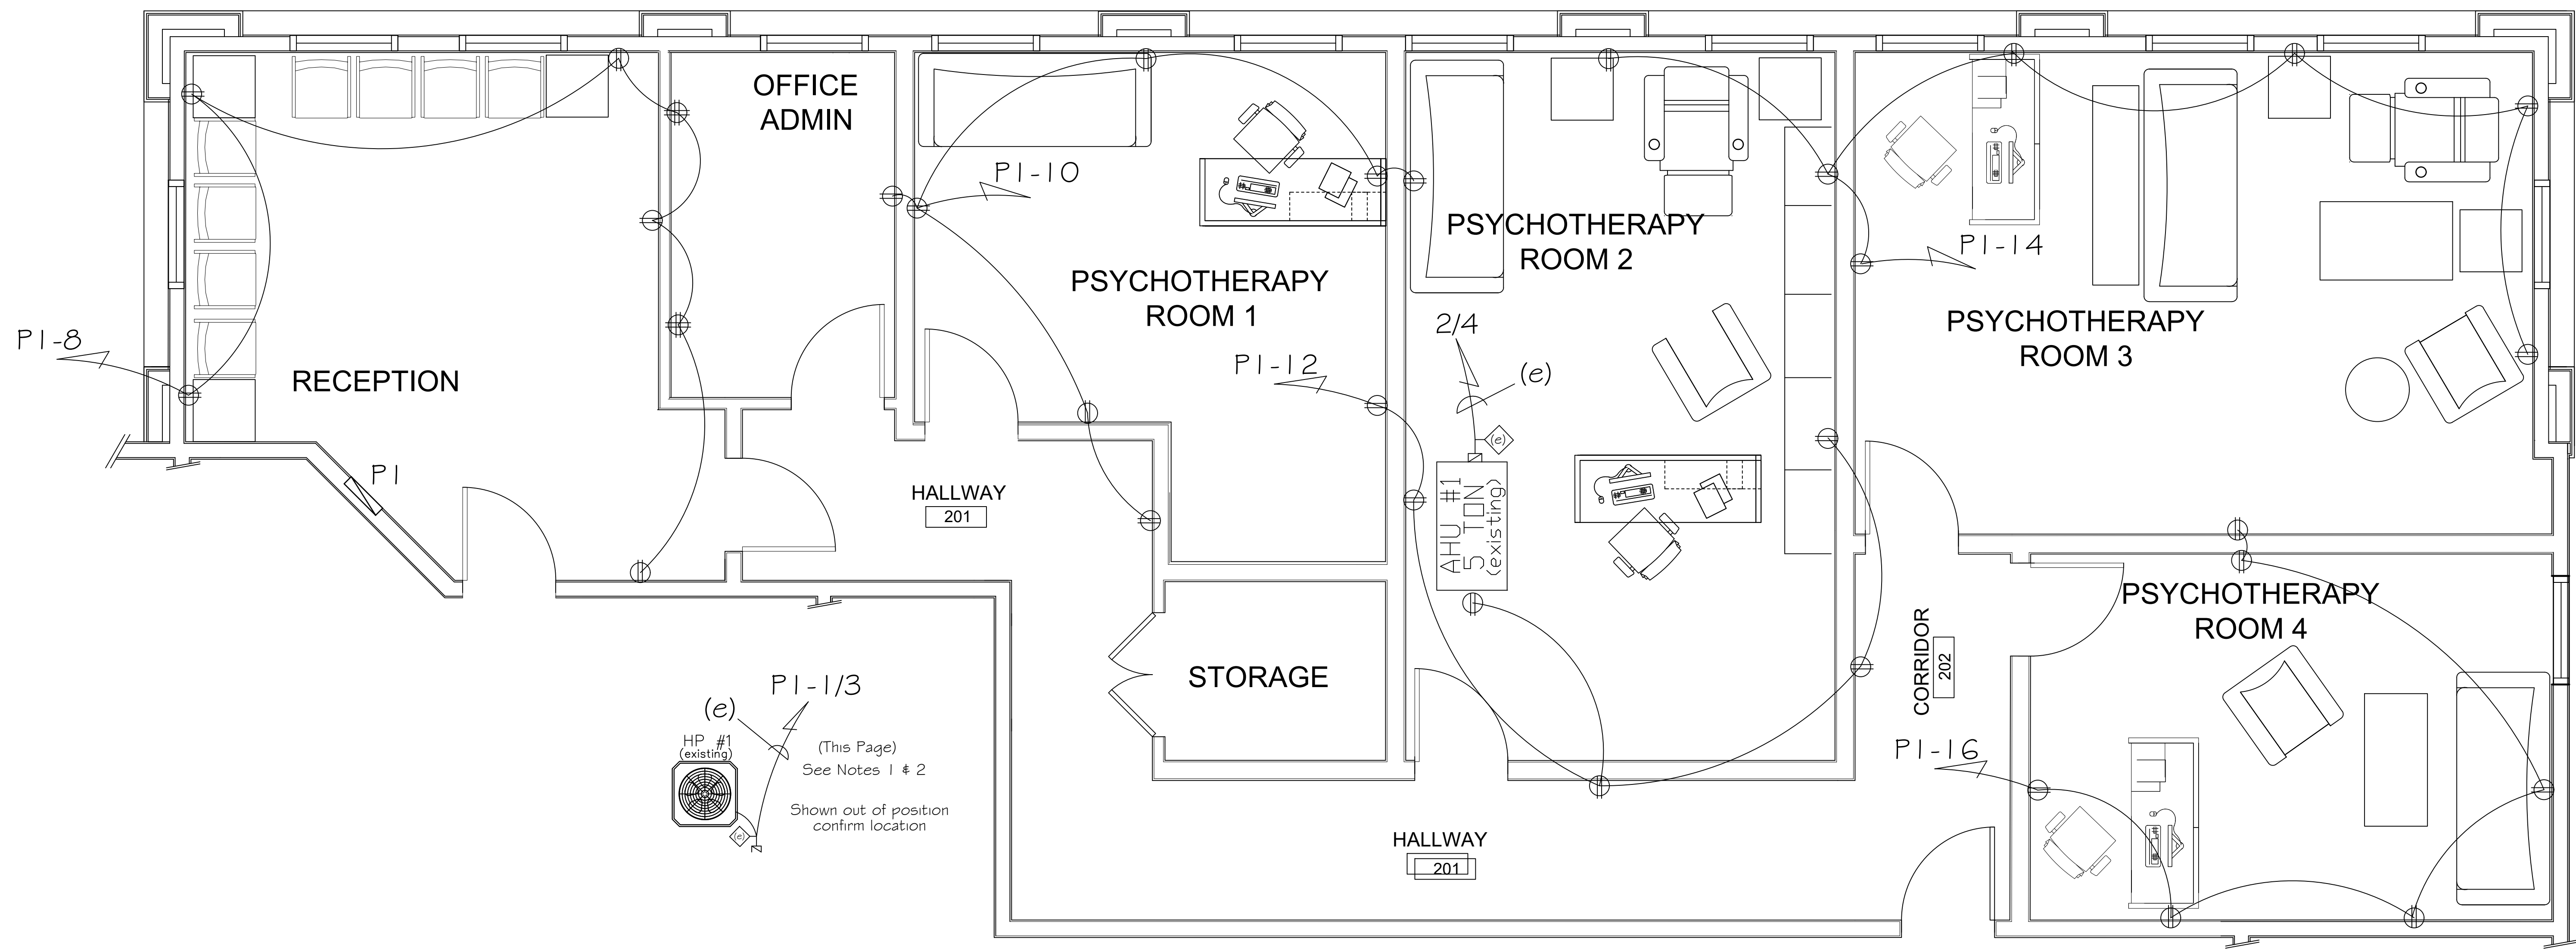


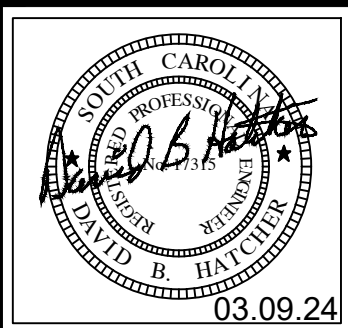

POWER PLAN
SCALE: 3/8" = 1' - 0"

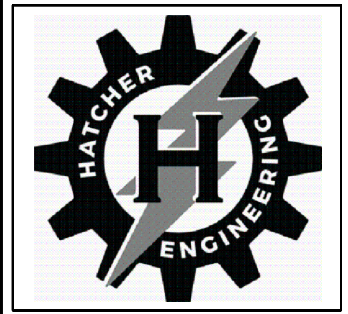

DAVID B HATCHER, PE, LLC
1039 STONEHEDGE DRIVE
HANAHAN, SC 29410
david@hatcher.engineering
phone: 843-860-9374
www.hatcher.engineering

REVISIONS	DATE	DESCRIPTION

DR ZORN	9102 BOWEN PIER DRIVE HANAHAN, SC	POWER PLAN
---------	--------------------------------------	------------