


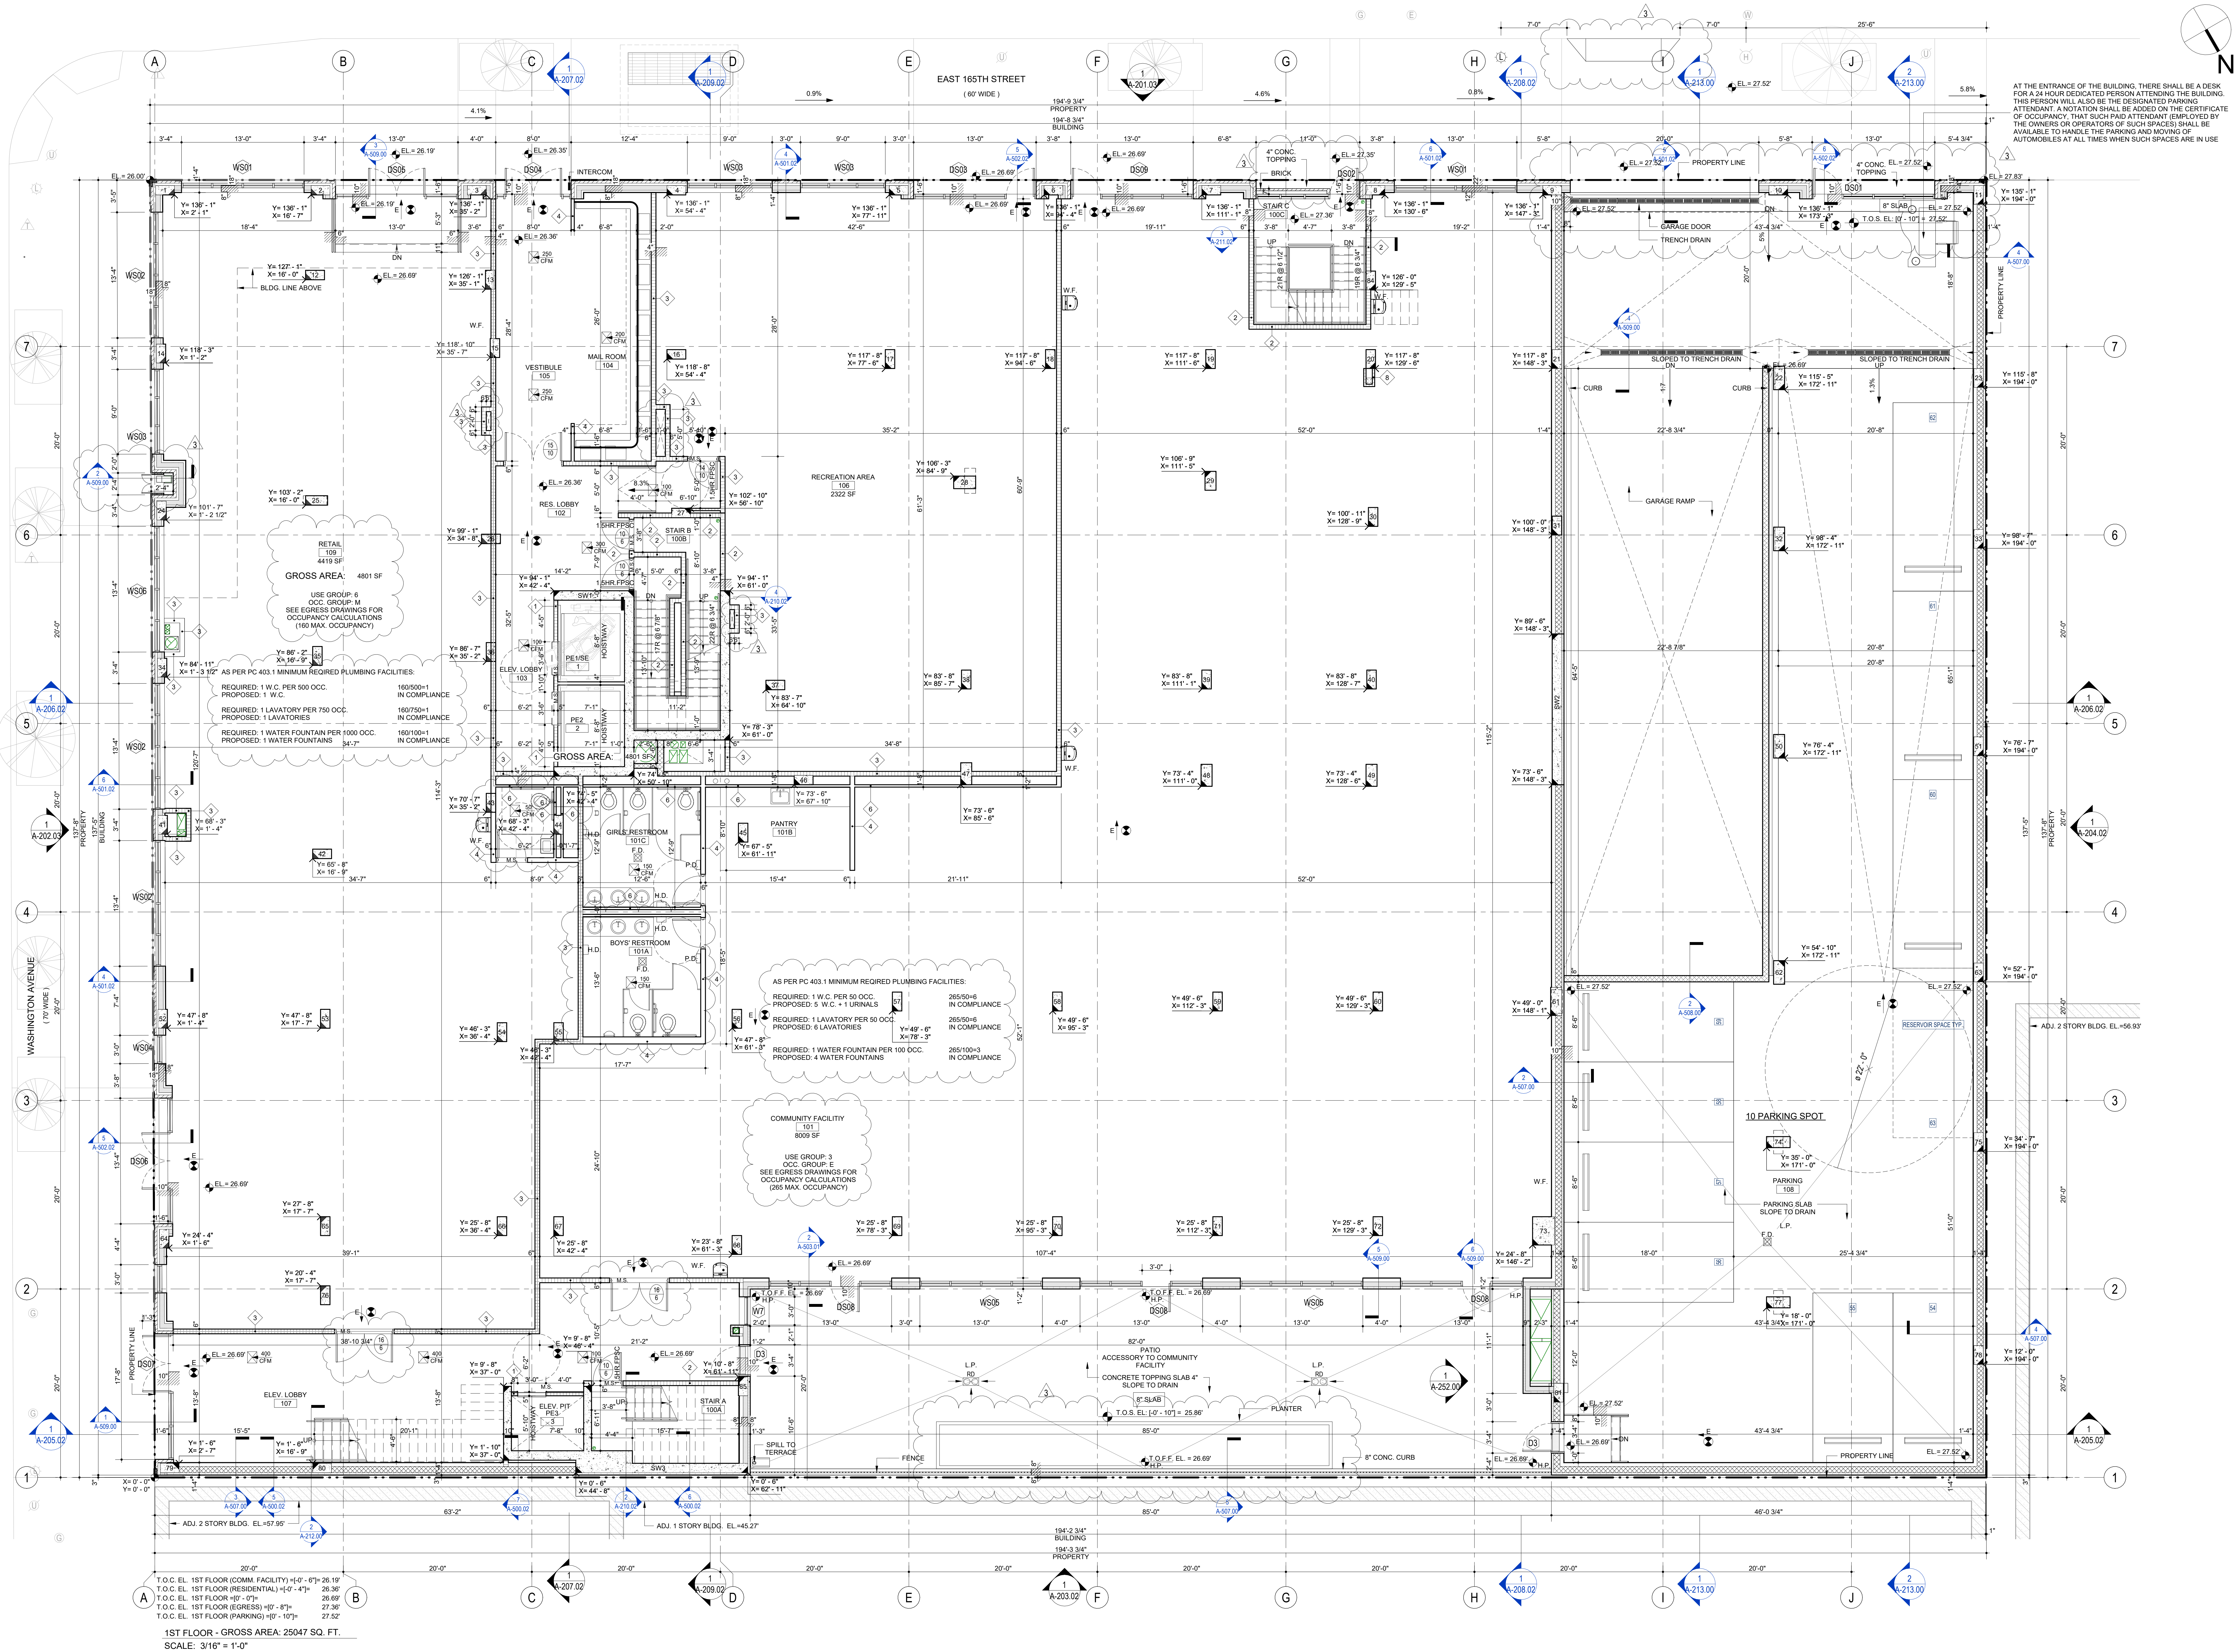

1ST FLOOR - GROSS AREA: 25047 SQ. FT.
SCALE: 3/16" = 1'-0"

DOB JOB NUMBER: X0088703-P3

OWNER / DEVELOPER	ARCHITECT	STRUCTURAL ENGINEER	MECHANICAL ENGINEER	PROJECT TITLE	DRAWING TITLE	REVISIONS/REVISION DATE	SEAL	DRAWING NUMBER: 19-01																																							
W RESIDENCE LLC 185-08 UNION TURNPIKE, SUITE 106 JAMAICA ESTATES, NY 11366	ISSAC & STERN ARCHITECTS, P.C 264 WEST 40TH STREET, PH FLOOR, NEW YORK, NY 10016 212-268-5500 INFO@ISSACSTERN.COM ISSACSTERN.COM	STRUCTURAL ENGINEERING TECHNOLOGIES, P.C. 40-12 20TH STREET LONG ISLAND CITY, NY 11101 (718) 706-7196	A & D ENGINEERING, PLLC 2008 East 15TH Street Brooklyn, NY 11235 (718) 872-6122	443 EAST 165TH STREET BRONX, NY 10456	1ST FLOOR PLAN	<table><tr><th>NO.</th><th>DATE</th><th>DESCRIPTION</th></tr><tr><td>1</td><td>08/09/2023</td><td>PLUMBING SET</td></tr><tr><td>2</td><td>10/10/2023</td><td>PAV.</td></tr><tr><td>3</td><td>01/10/2024</td><td>PAV.02</td></tr><tr><td> </td><td> </td><td> </td></tr><tr><td> </td><td> </td><td> </td></tr><tr><td> </td><td> </td><td> </td></tr><tr><td> </td><td> </td><td> </td></tr><tr><td> </td><td> </td><td> </td></tr><tr><td> </td><td> </td><td> </td></tr><tr><td> </td><td> </td><td> </td></tr><tr><td> </td><td> </td><td> </td></tr><tr><td> </td><td> </td><td> </td></tr></table>	NO.	DATE	DESCRIPTION	1	08/09/2023	PLUMBING SET	2	10/10/2023	PAV.	3	01/10/2024	PAV.02																													A-101.03
NO.	DATE	DESCRIPTION																																													
1	08/09/2023	PLUMBING SET																																													
2	10/10/2023	PAV.																																													
3	01/10/2024	PAV.02																																													
SCALE AS SHOWN																																															

A-101.03