


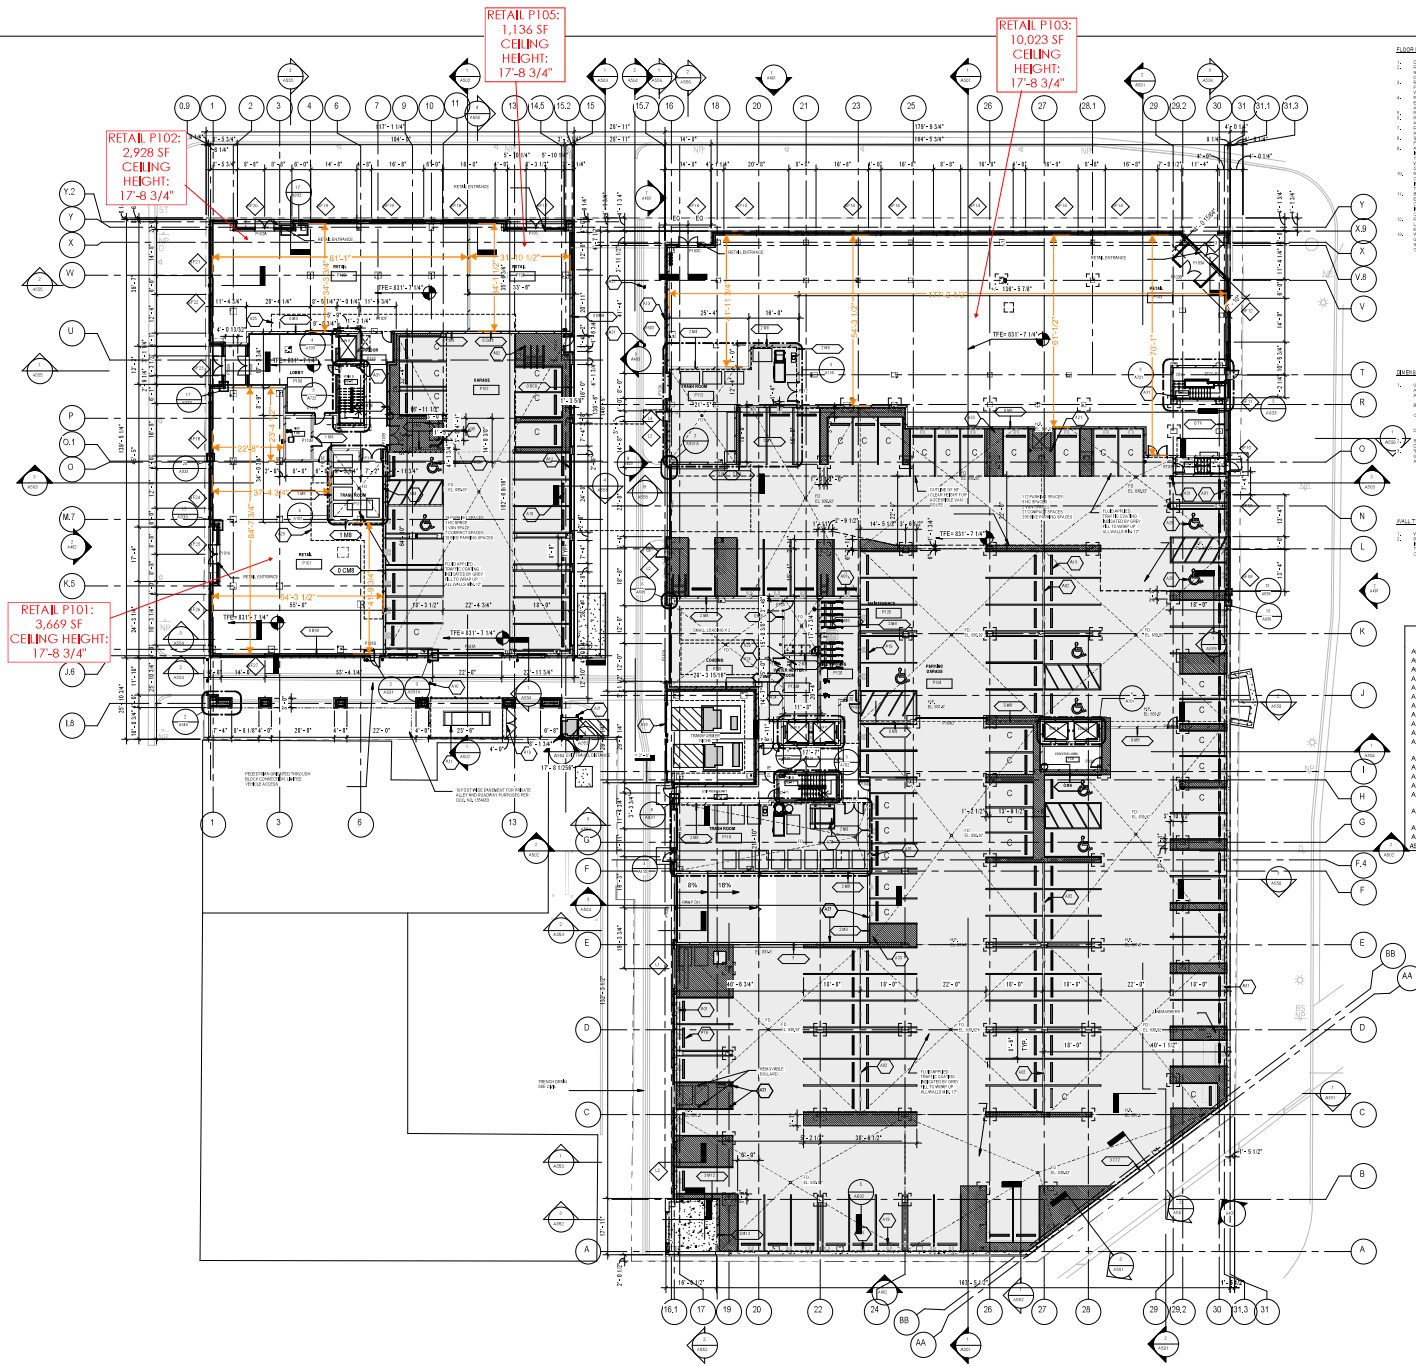

GENERAL NOTES

1. CONSULT ARCHITECT FOR ALL NOTES.
2. ALL WORK SHALL BE IN ACCORDANCE WITH THE LATEST EDITIONS OF THE BUILDING CODES AND ALL APPLICABLE SPECIFICATIONS.
3. ALL MATERIALS AND METHODS OF CONSTRUCTION SHALL BE APPROVED BY THE ARCHITECT PRIOR TO INSTALLATION.
4. ALL WORK SHALL BE COMPLETED WITHIN THE SPECIFIED TIME FRAME.
5. ALL WORK SHALL BE COMPLETED WITHIN THE SPECIFIED BUDGET.
6. ALL WORK SHALL BE COMPLETED WITHIN THE SPECIFIED QUALITY STANDARDS.
7. ALL WORK SHALL BE COMPLETED WITHIN THE SPECIFIED SAFETY STANDARDS.
8. ALL WORK SHALL BE COMPLETED WITHIN THE SPECIFIED ENVIRONMENTAL STANDARDS.
9. ALL WORK SHALL BE COMPLETED WITHIN THE SPECIFIED ACCESSIBILITY STANDARDS.
10. ALL WORK SHALL BE COMPLETED WITHIN THE SPECIFIED HISTORIC PRESERVATION STANDARDS.

REVISIONS

NO.	DATE	DESCRIPTION
1	07/20/2022	ISSUED FOR PERMIT
2	07/20/2022	ISSUED FOR DESIGN
3	07/20/2022	ISSUED FOR PERMIT
4	07/20/2022	ISSUED FOR PERMIT
5	07/20/2022	ISSUED FOR PERMIT
6	07/20/2022	ISSUED FOR PERMIT
7	07/20/2022	ISSUED FOR PERMIT
8	07/20/2022	ISSUED FOR PERMIT
9	07/20/2022	ISSUED FOR PERMIT
10	07/20/2022	ISSUED FOR PERMIT

ARCHITECTURAL KEYNOTES

A01 VALL HUNG LIKE BACK - SEE SPEC SECTION 10000, TYP.

A02 FLOOR MOUNTED DING BACK - SEE SPEC 10000, TYP.

A03 ACCESS LOCKER VENT CASE

A04 (A04-B) 6" X 6" FT HIGH MESH PANEL FENCE W/ 4" X 4" DING GATES

A05 GENERATOR W/ DING FOR DING

A06 VIBE MESH FENCE AND LOW VIBRATION

A07 SAGHETTES, REFER TO SPEC DING

A08 BOLLARD, TYP. REFER TO SPEC DING

A09 PRECAST CONCRETE VIBES STOP

A10 MESH BOLLARDS

A11 VERTICAL TRASH COLLECTION - COORDINATE WITH ELECTRICAL

A12 PROVIDE FUTURE HOOKUPS FOR VIBER AND DRYER

A13 PROVIDE FUTURE HOOKUP FOR VIBER

A14 AREA OF SLAB LEAVE OUT FOR FUTURE PLUMBING

A15 4" X 4" VIBER CONCRETE WALL

A16 VIBER ACCESSIBLE PARKING SPOT SLOPES SHALL BE NO GREATER THAN 1% MAXIMUM IN 4" VERTICAL CLEARANCE

A17 STAMPING LOCATION, SEE FIRE PROTECTION DRAWINGS FOR ADDITIONAL INFORMATION

A18 ELECTRICAL DISTRIBUTION PANEL LOCATION

A19 HOUSEHOLD LOCATION, SEE PLUMBING DING

A20 REFER PARALLEL, SEE DING

B K V
GROUP

Architect
Interior Design
Landscape
Architect

200 South LaSalle Street
The Recovery
Suite 700
Chicago, IL
60604
312.779.0400
www.bkvgroup.com

CivilSite
GROUP

**Dinkytown
McDonald's
Redevelopment**

ISSUE #	DATE	DESCRIPTION
1	07/20/2022	SCHEMATIC DESIGN
2	07/20/2022	ISSUED FOR DESIGN
3	07/20/2022	ISSUED FOR PERMIT
4	07/20/2022	ISSUED FOR PERMIT
5	07/20/2022	ISSUED FOR PERMIT
6	07/20/2022	ISSUED FOR PERMIT
7	07/20/2022	ISSUED FOR PERMIT
8	07/20/2022	ISSUED FOR PERMIT
9	07/20/2022	ISSUED FOR PERMIT
10	07/20/2022	ISSUED FOR PERMIT

CERTIFICATION

SHEET TITLE

LEVEL P1 & NORTH RETAIL - OVERALL FLOOR PLAN

SHEET NUMBER

A099

© 2021 B K V Group